
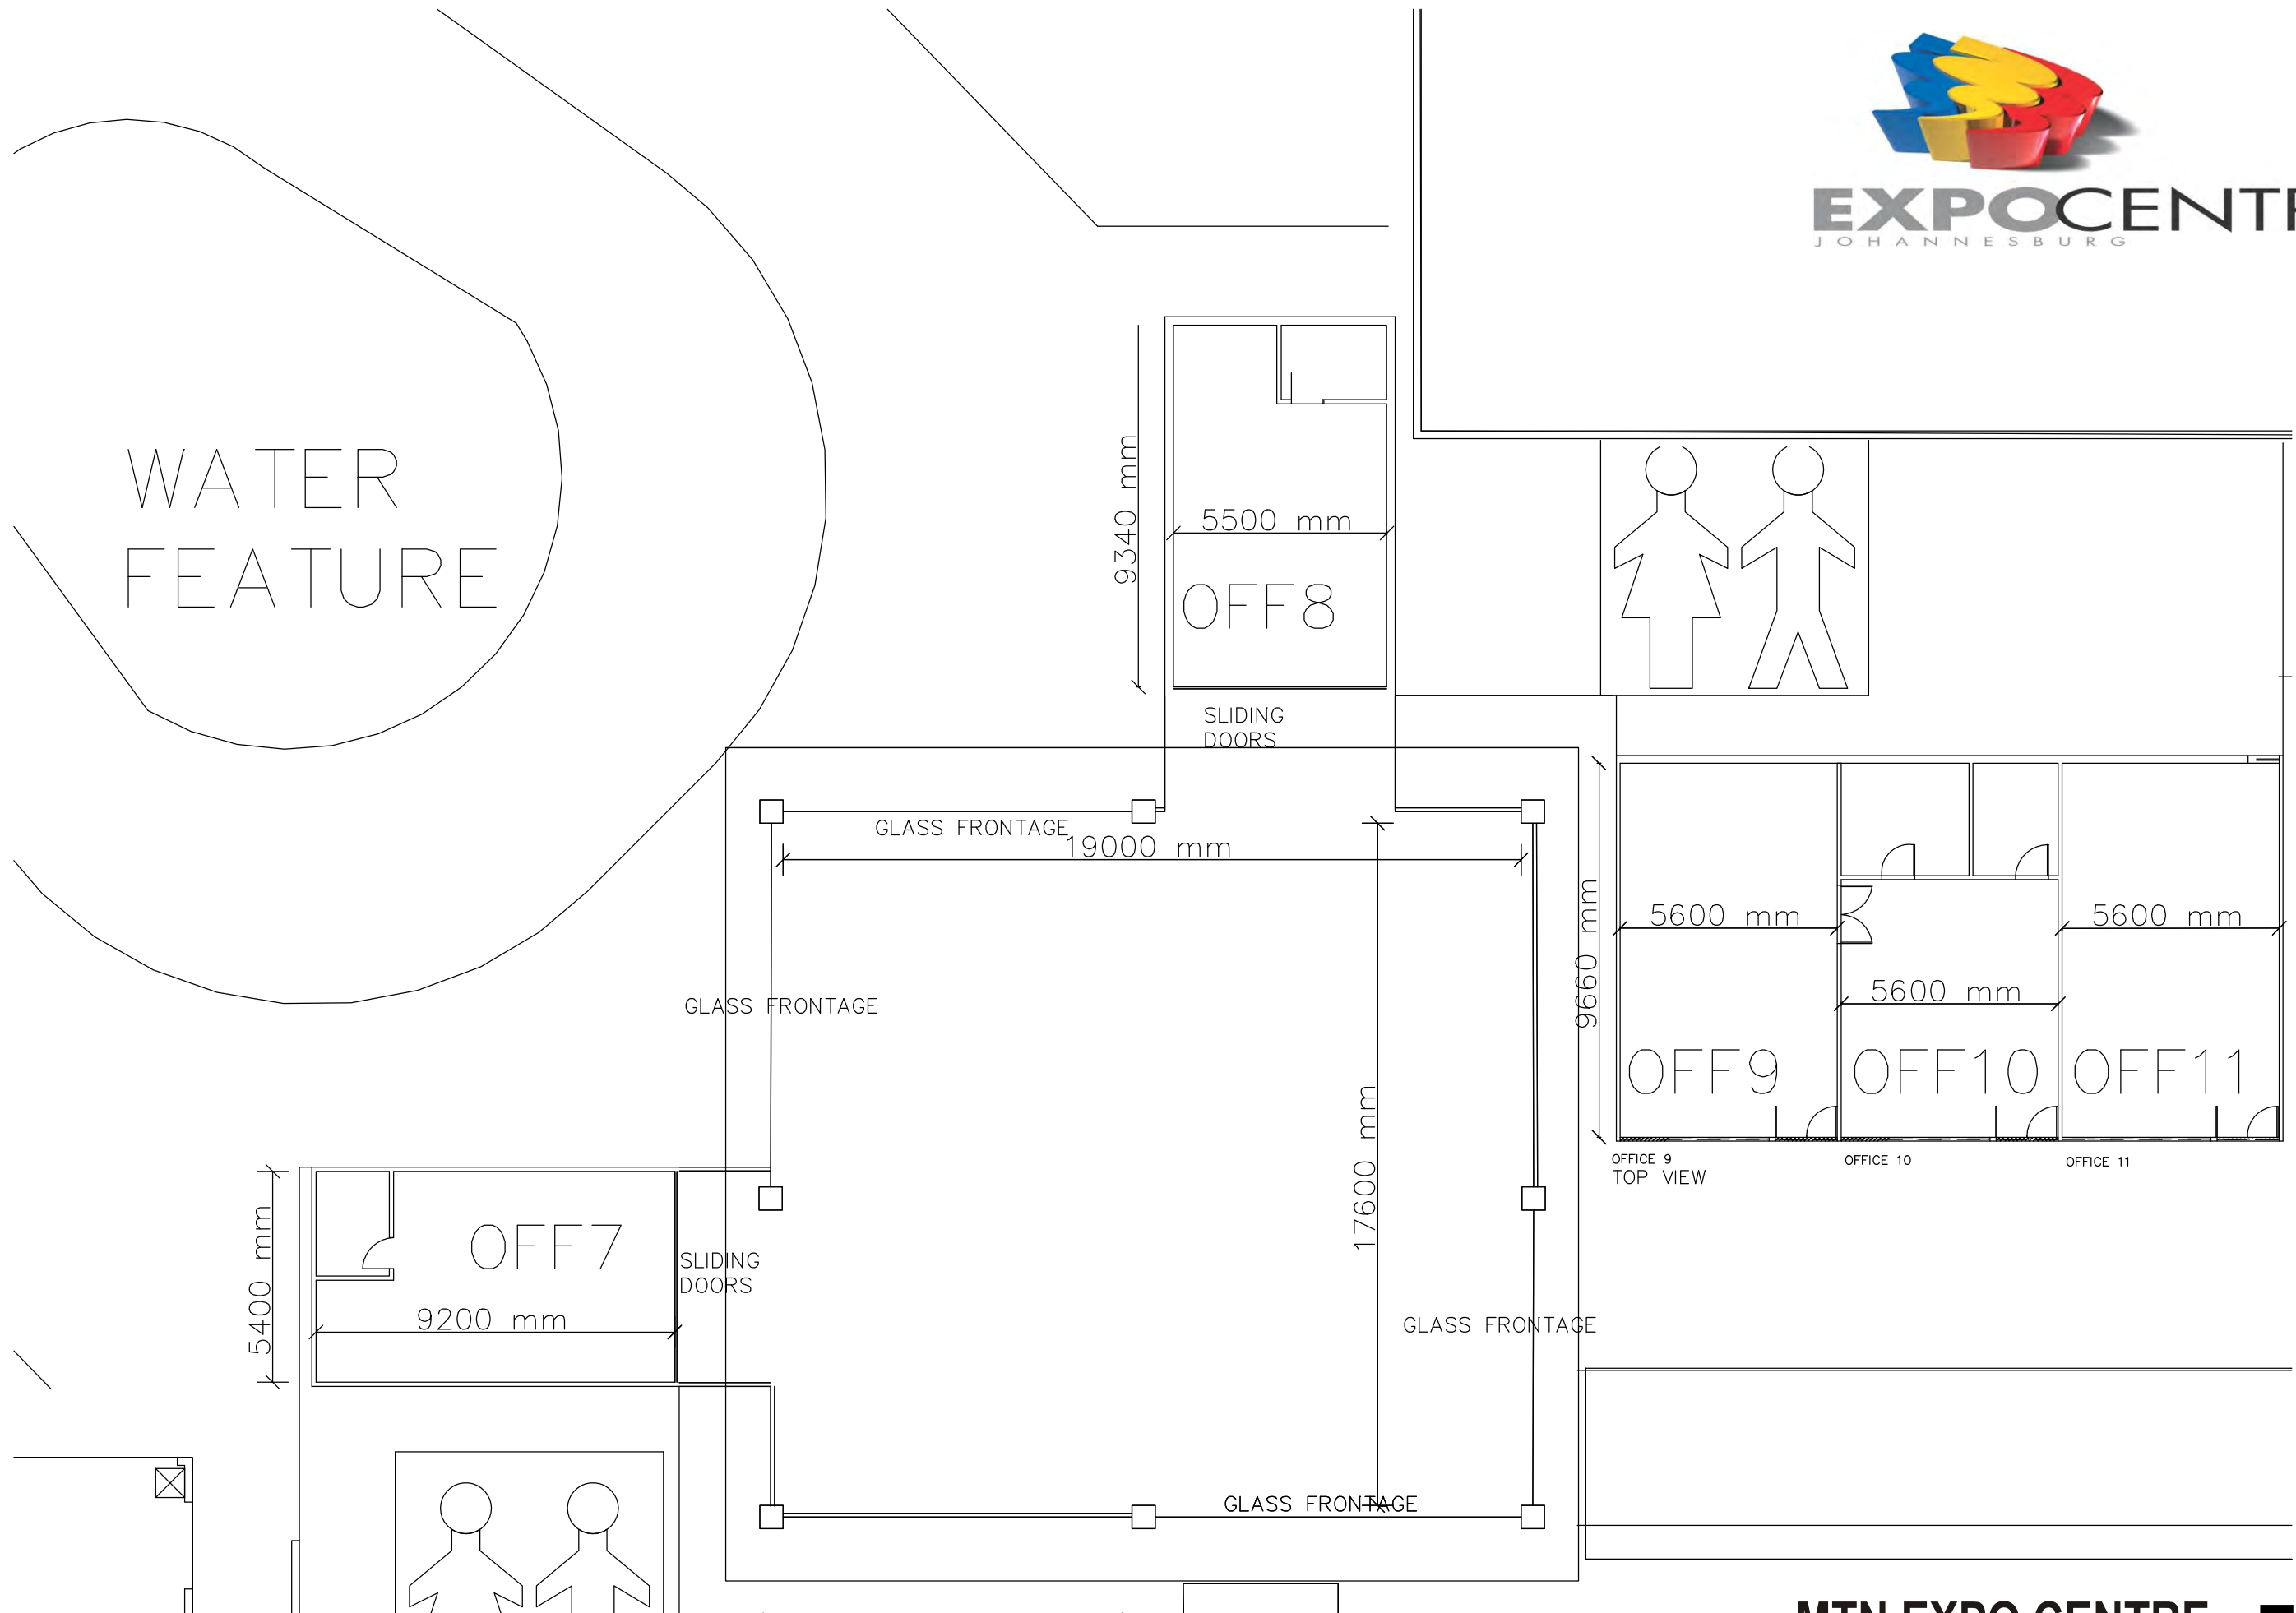
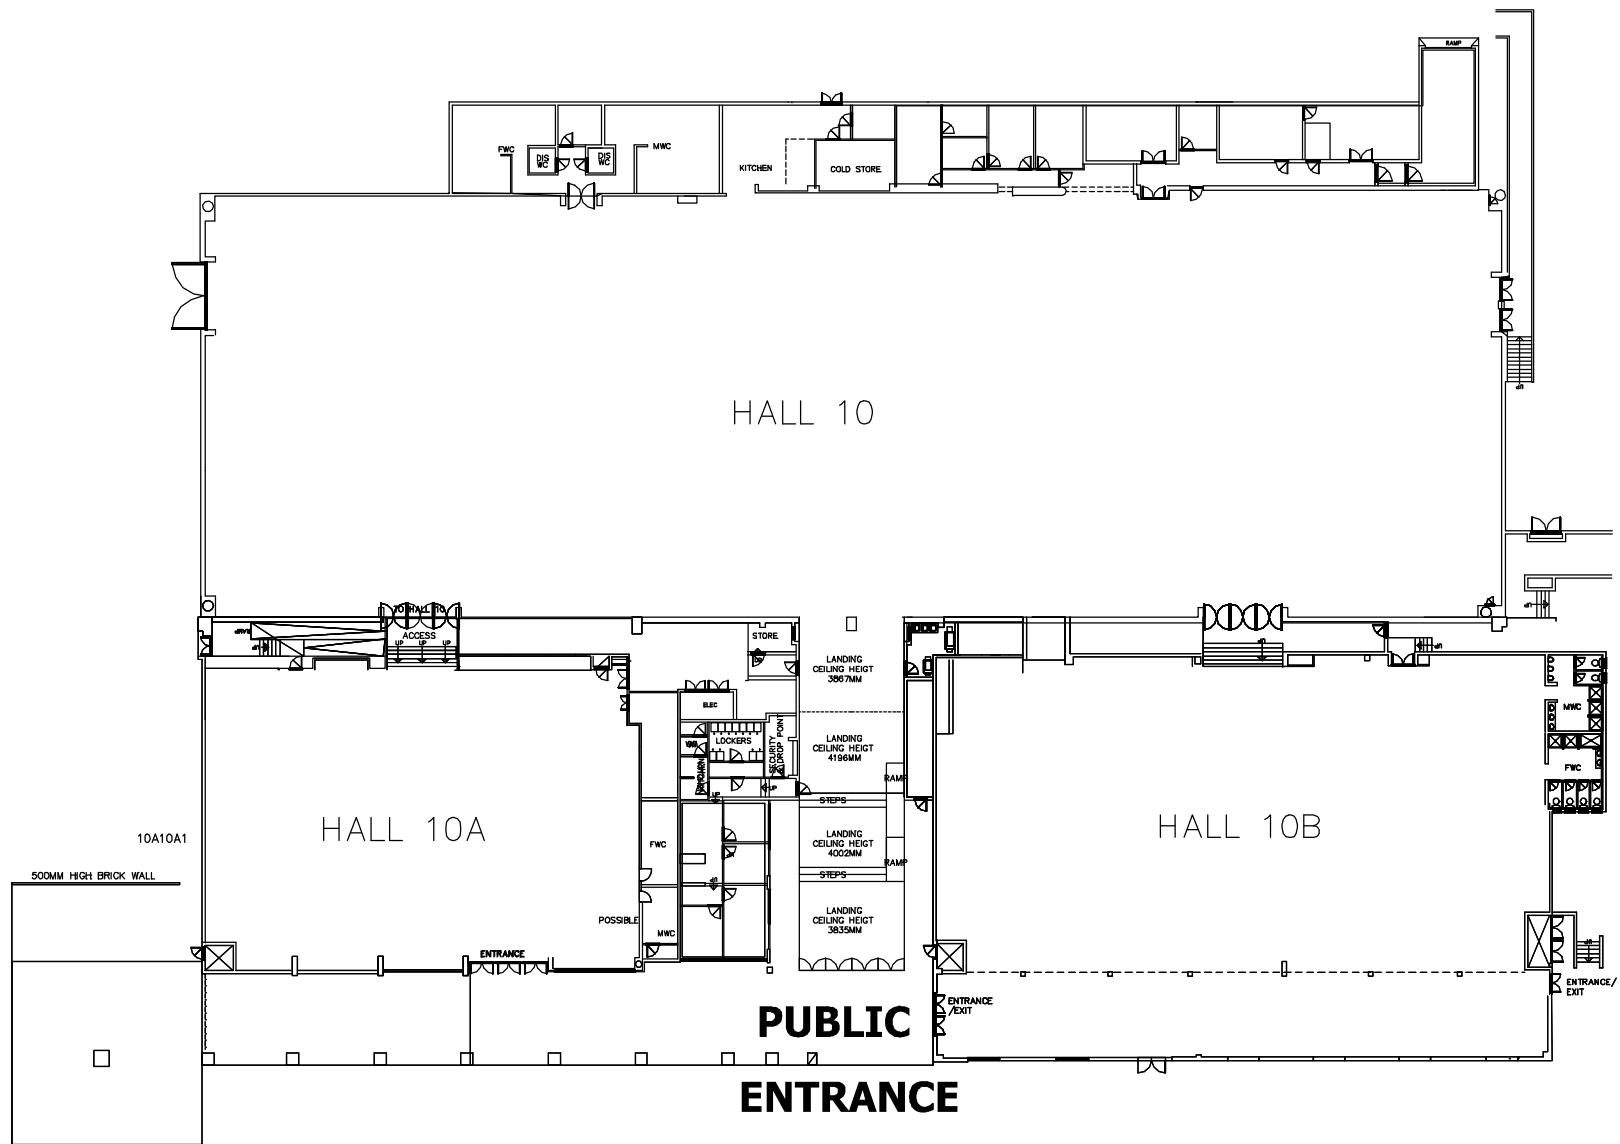


LINK ENTRANCE 5/6

NOTE:	LEGEND:	DESCRIPTION:
<p>1. CEILING HEIGHT: GENERAL CEILING: 5150MM BULKHEAD: 4644MM IN CENTRE OF BULKHEAD: 5142MM</p> <p>SCALE: 1M 10M PLOTTED ON A3: 1:200</p>	<ul style="list-style-type: none"> FIRE HOSEREEL AND 2 FIRE EXTINGUISHERS FIRE HOSEREEL AND 1 FIRE EXTINGUISHER FIRE HOSEREEL FIRE EXTINGUISHER DISTRIBUTION BOARD <p>DISCLAIMER: CARE HAS BEEN TAKEN TO ENSURE THAT MEASUREMENTS ON THIS FLOOR PLAN ARE CORRECT. HOWEVER, IT IS THE CLIENTS RESPONSIBILITY TO VERIFY THE CORRECTNESS OF THE MEASUREMENTS AND INFORMATION.</p>	<p>P1 PUBLIC ENTRANCE GLASS DOORS FROM TURNSTYLE 5/6 INTO LINK</p> <p>P2 PUBLIC ENTRANCE GLASS DOORS FROM LINK ENTRANCE INTO SITE</p> <div style="text-align: center;">  </div>





HALL 10

GROSS AREA 2 420M²

NOTE:

1. LIGHTING: SODIUM VAPOUR
2. PUBLIC ADDRESS: AVAILABLE ON REQUEST
3. CEILING HEIGHT:
AT APEX: 8,2M
UNDERSIDE OF CONCRETE BEAMS: 6M
4. CONCRETE COLUMN Ø 600MM
5. SERVICE DUCTS INCLUDE:
WATER
ELECTRICITY
TELEPHONE/FAX
6. FLOOR LOADING: 7,5 TONNES/M³
- OVER DUCTS 3,5 TON/MSQ
7. COMPRESSED AIR: AVAILABLE ON REQUEST
8. POWER SUPPLY: 380VOLT 5 WIRE 3 PHASE

SCALE:



PLOTTED ON A3: 1:500

DISCLAIMER:

CARE HAS BEEN TAKEN TO ENSURE THAT MEASUREMENTS ON THIS FLOOR PLAN ARE CORRECT. HOWEVER, IT IS THE CLIENTS RESPONSIBILITY TO VERIFY THE CORRECTNESS OF THE MEASUREMENTS AND INFORMATION.

LEGEND:


- ⊗ FIRE HOSEREEL AND 2 FIRE EXTINGUISHERS
- ⊖ FIRE HOSEREEL AND 1 FIRE EXTINGUISHER
- FIRE HOSEREEL
- ◇ FIRE EXTINGUISHER
- ▨ DISTRIBUTION BOARD

DESCRIPTION:

- DOOR HEIGHT RESTRICTIONS:
- SERVICE DOORS 1 OFF 2M HIGH + 4,5M
 - ROLLER SHUTTER DOORS: 2 OFF 2M HIGH + 1,5M

 


 


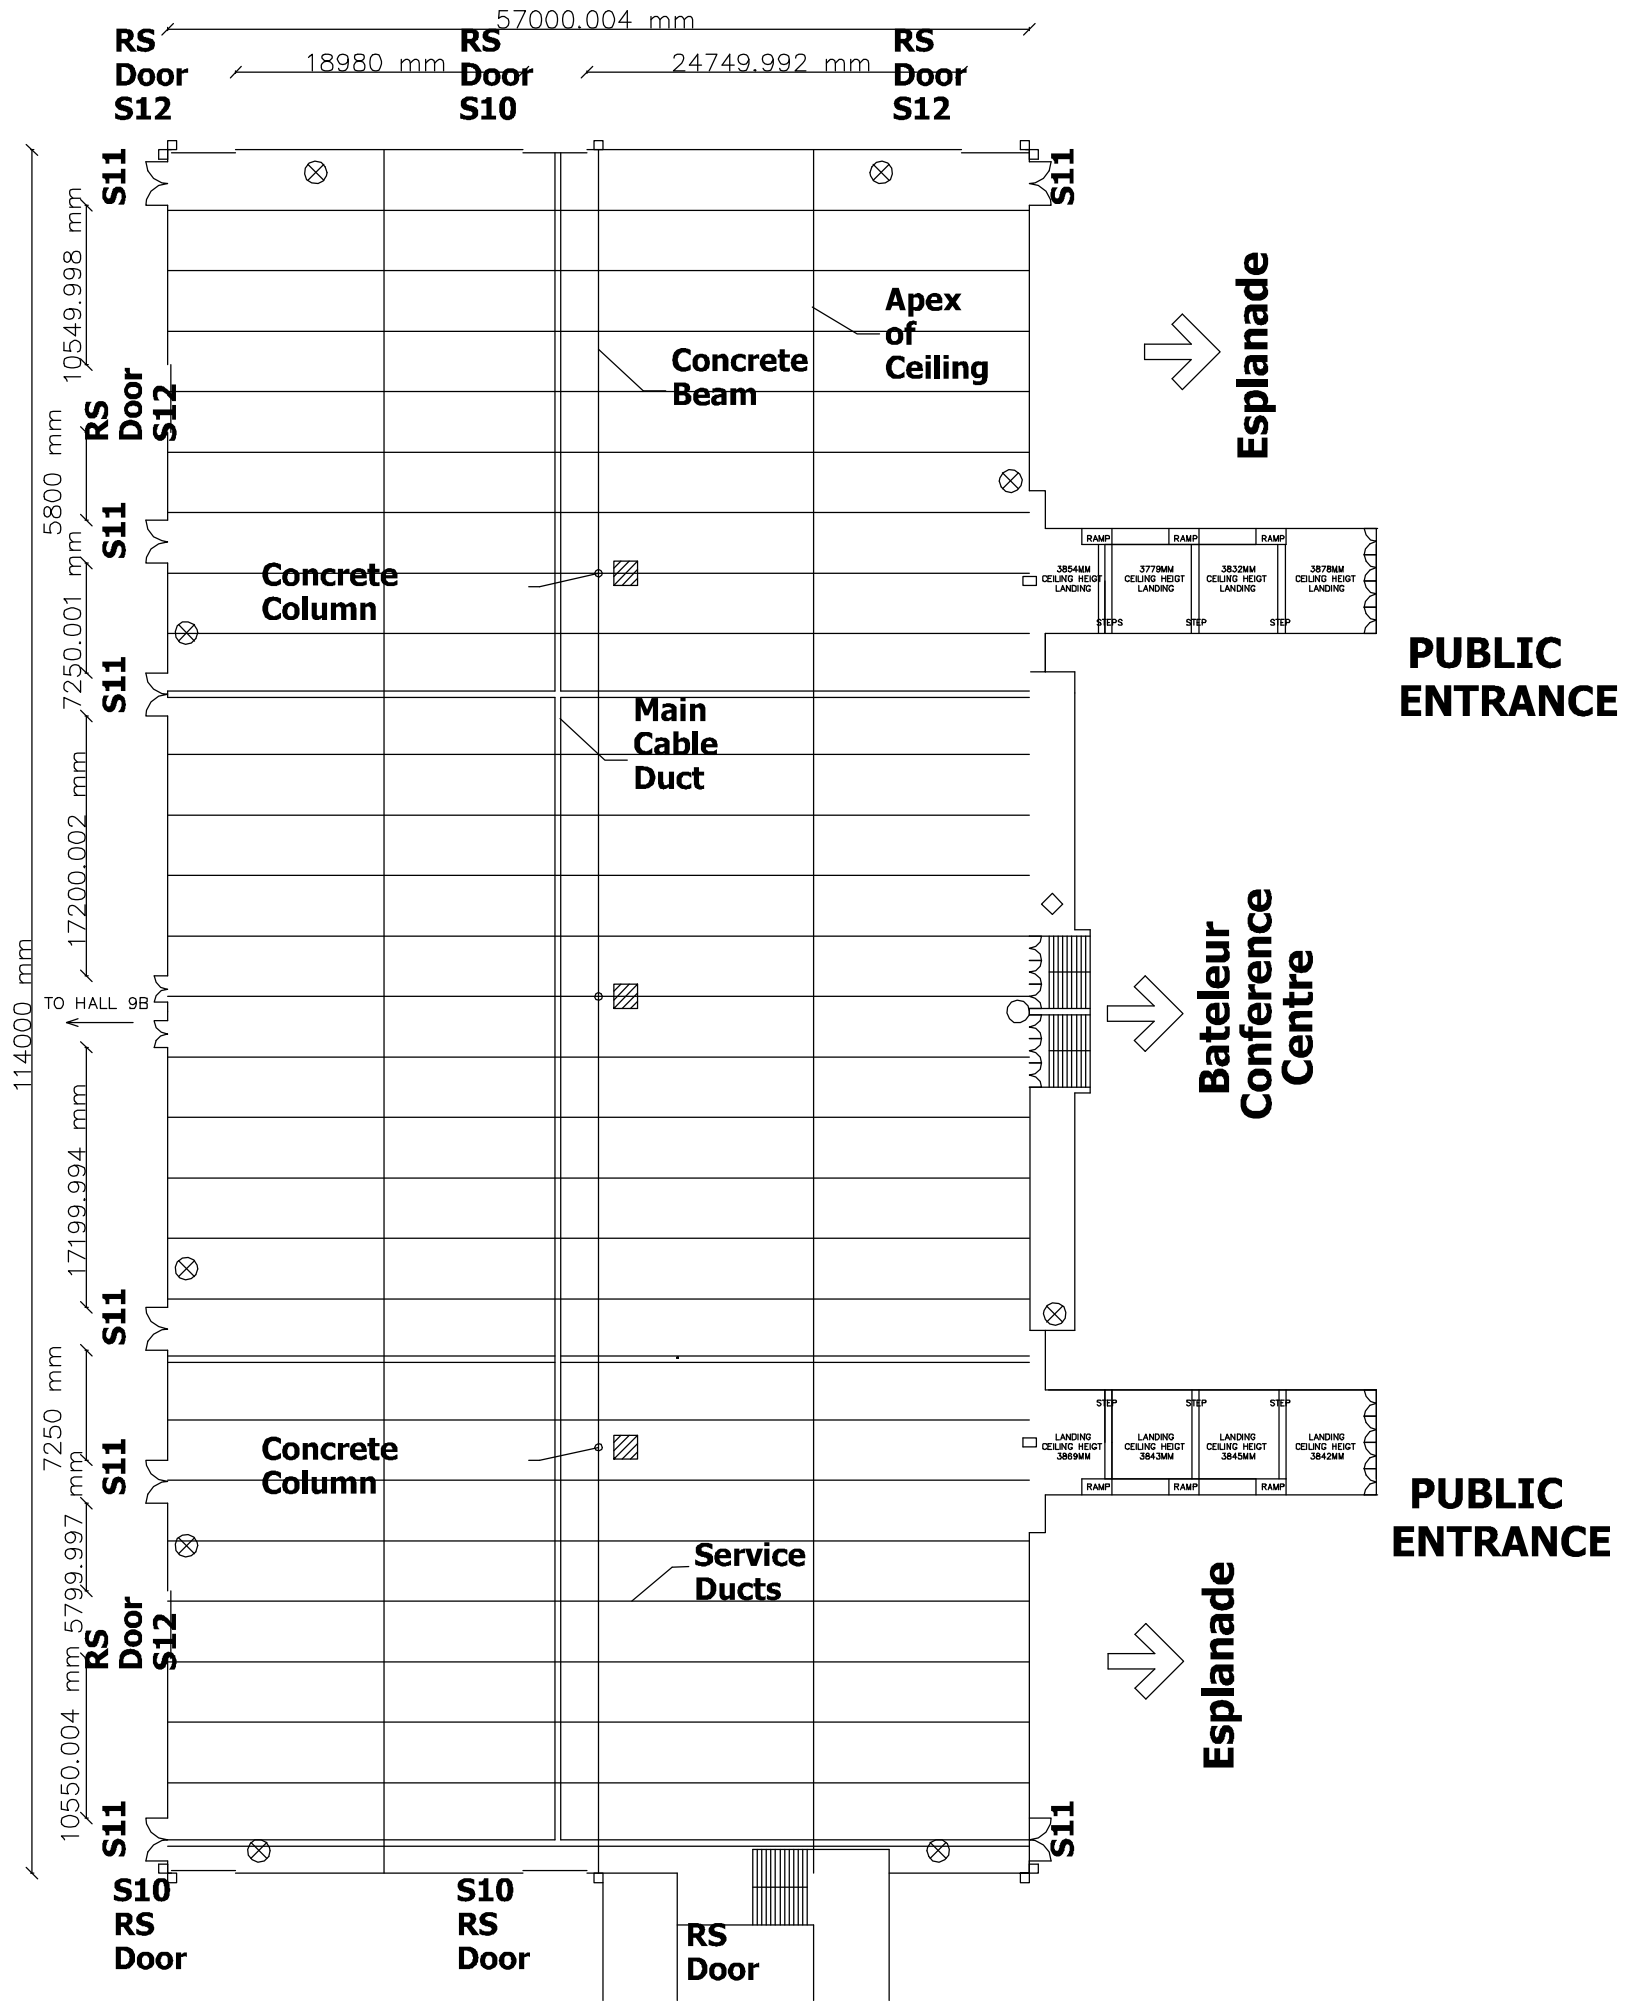


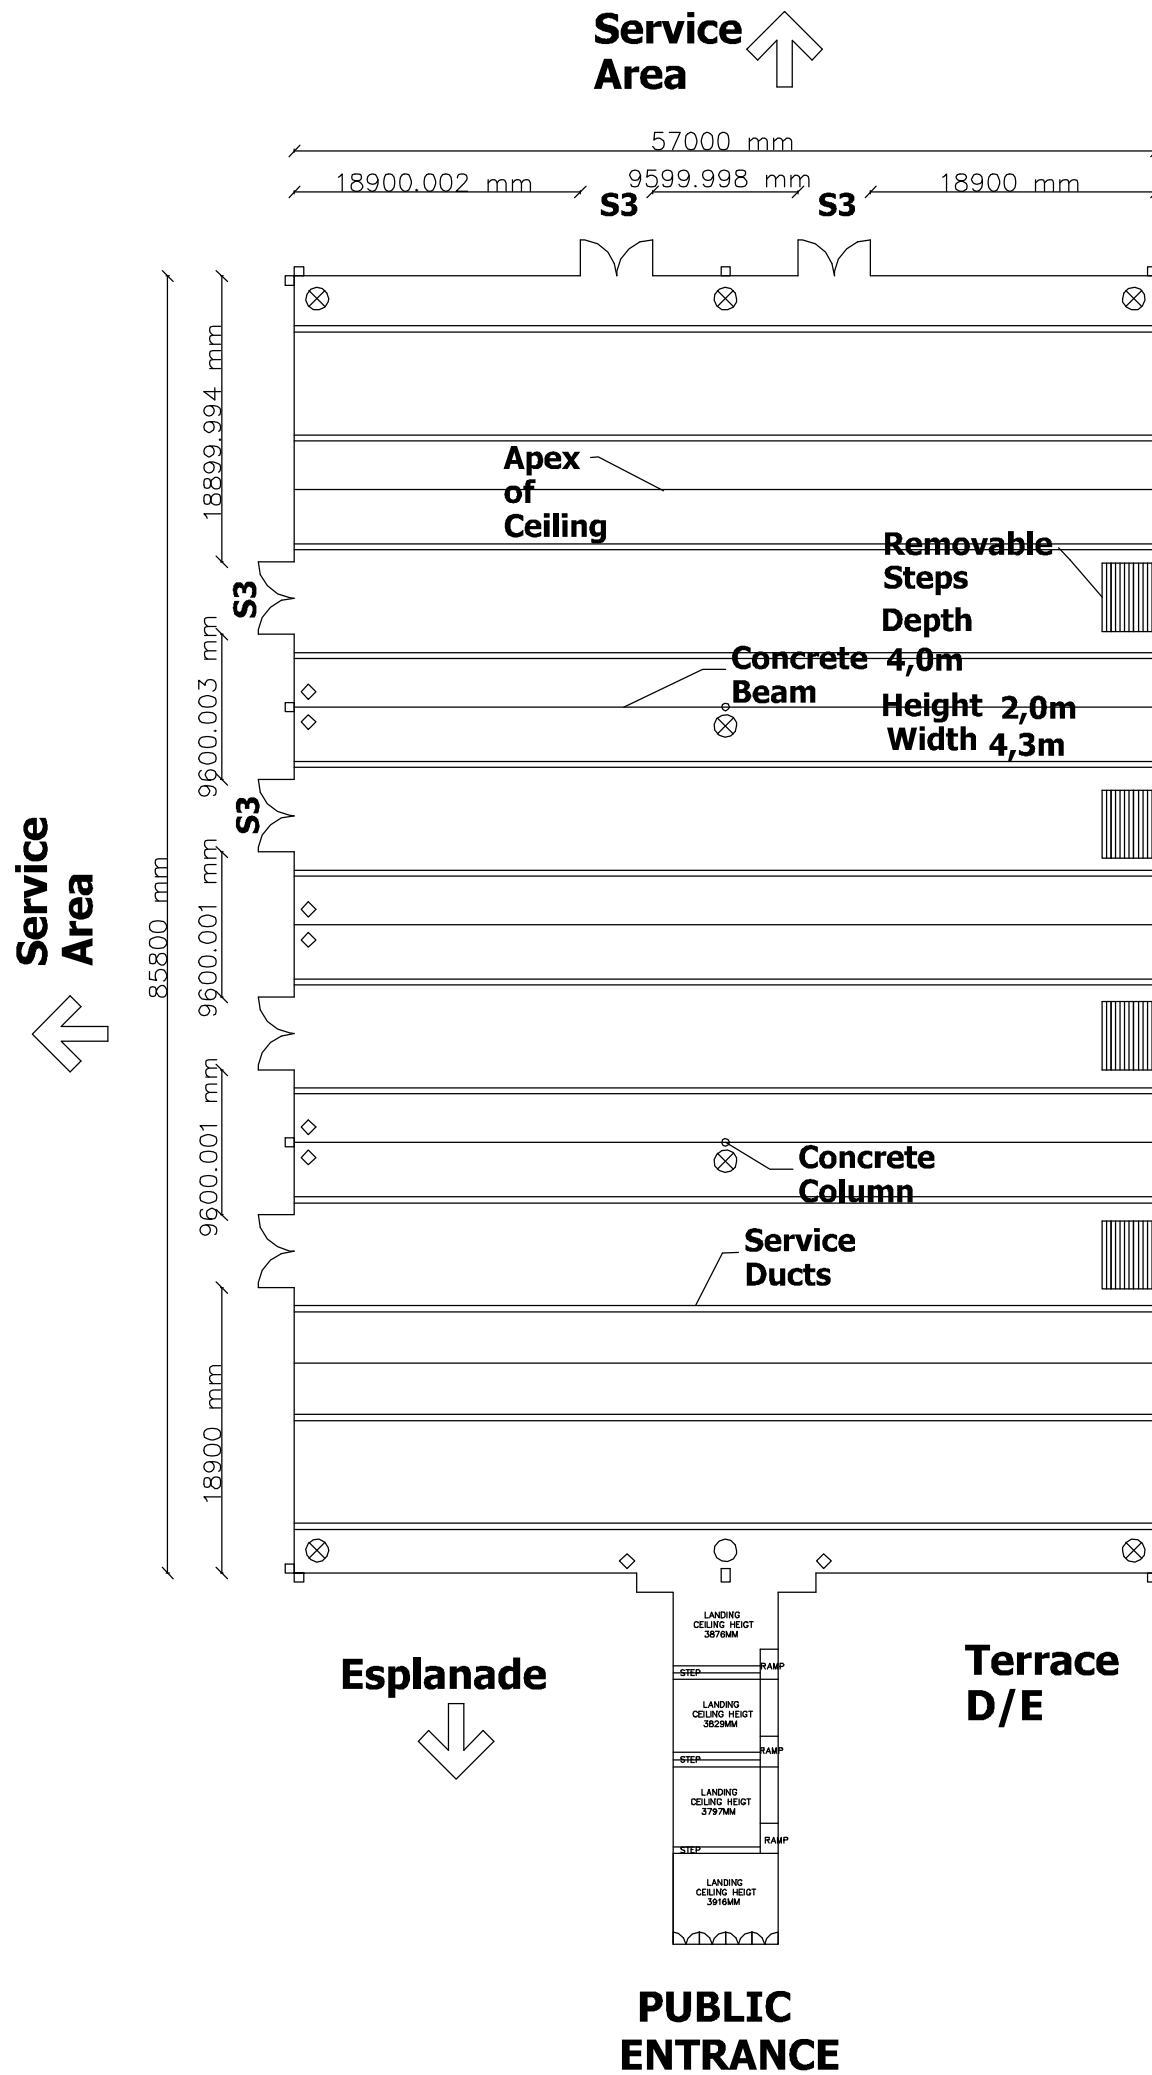
EXPOCENTRE
JOHANNESBURG



HALL 9

GROSS AREA 6 532M²

<p>NOTE:</p> <ol style="list-style-type: none"> LIGHTING: SODIUM VAPOUR PUBLIC ADDRESS: AVAILABLE ON REQUEST CEILING HEIGHT: AT APEX: 8.2M UNDERSIDE OF CONCRETE BEAMS: 6M CONCRETE COLUMN Ø 600MM SERVICE DUCTS INCLUDE: WATER ELECTRICITY TELEPHONE/FAX FLOOR LOADING: 15 TONNES/M³ COMPRESSED AIR: AVAILABLE ON REQUEST POWER SUPPLY: 380VOLT 5 WIRE 3 PHASE 	<p>SCALE:</p> <p>1M  10M</p> <p>PLOTTED ON A3: 1:500</p> <p>DISCLAIMER: CARE HAS BEEN TAKEN TO ENSURE THAT MEASUREMENTS ON THIS FLOOR PLAN ARE CORRECT. HOWEVER, IT IS THE CLIENTS RESPONSIBILITY TO VERIFY THE CORRECTNESS OF THE MEASUREMENTS AND INFORMATION.</p>	<p>LEGEND:</p> <ul style="list-style-type: none">  FIRE HOSEREEL AND 2 FIRE EXTINGUISHERS  FIRE HOSEREEL AND 1 FIRE EXTINGUISHER  FIRE HOSEREEL  FIRE EXTINGUISHER  DISTRIBUTION BOARD 	<p>DESCRIPTION:</p> <p>S10 Service Entrance</p> <p>S11 Service Entrance</p> <p>S12 Service Entrance</p>	<p>HEIGHT:</p> <p>5,500 m</p> <p>2,030 m</p> <p>5,500 m</p>	<p>WIDTH:</p> <p>4,800 m</p> <p>2,850 m</p> <p>5,500 m</p>
					



HALL 8

GROSS AREA 4 890M²

NOTE:

1. LIGHTING: SODIUM VAPOUR
2. PUBLIC ADDRESS: AVAILABLE ON REQUEST
3. CEILING HEIGHT:
AT APEX: 8,2M
UNDERSIDE OF CONCRETE BEAMS: 6M
4. CONCRETE COLUMN Ø 600MM
5. SERVICE DUCTS INCLUDE:
WATER
ELECTRICITY
TELEPHONE/FAX
6. FLOOR LOADING: 15 TONNES/M³
7. COMPRESSED AIR: AVAILABLE ON REQUEST
8. POWER SUPPLY: 380VOLT 5 WIRE 3 PHASE

SCALE:

1M 10M

PLOTTED ON A3: 1: 500

DISCLAIMER:

CARE HAS BEEN TAKEN TO ENSURE THAT MEASUREMENTS ON THIS FLOOR PLAN ARE CORRECT. HOWEVER, IT IS THE CLIENTS RESPONSIBILITY TO VERIFY THE CORRECTNESS OF THE MEASUREMENTS AND INFORMATION.

LEGEND:

- FIRE HOSEREEL AND 2 FIRE EXTINGUISHERS
- FIRE HOSEREEL AND 1 FIRE EXTINGUISHER
- FIRE HOSEREEL
- FIRE EXTINGUISHER

DESCRIPTION:

- S1 Service Entrance**
- S2 Service Entrance**
- S3 Service Entrance**
- S4 Service Entrance**

HEIGHT:


- 4,000 m**
- 5,600 m**
- 5,500 m**
- 2,900 m**

WIDTH:

- 4,800 m**
- 7,200 m**
- 4,800 m**
- 4,800 m**




EXPOCENTRE
JOHANNESBURG

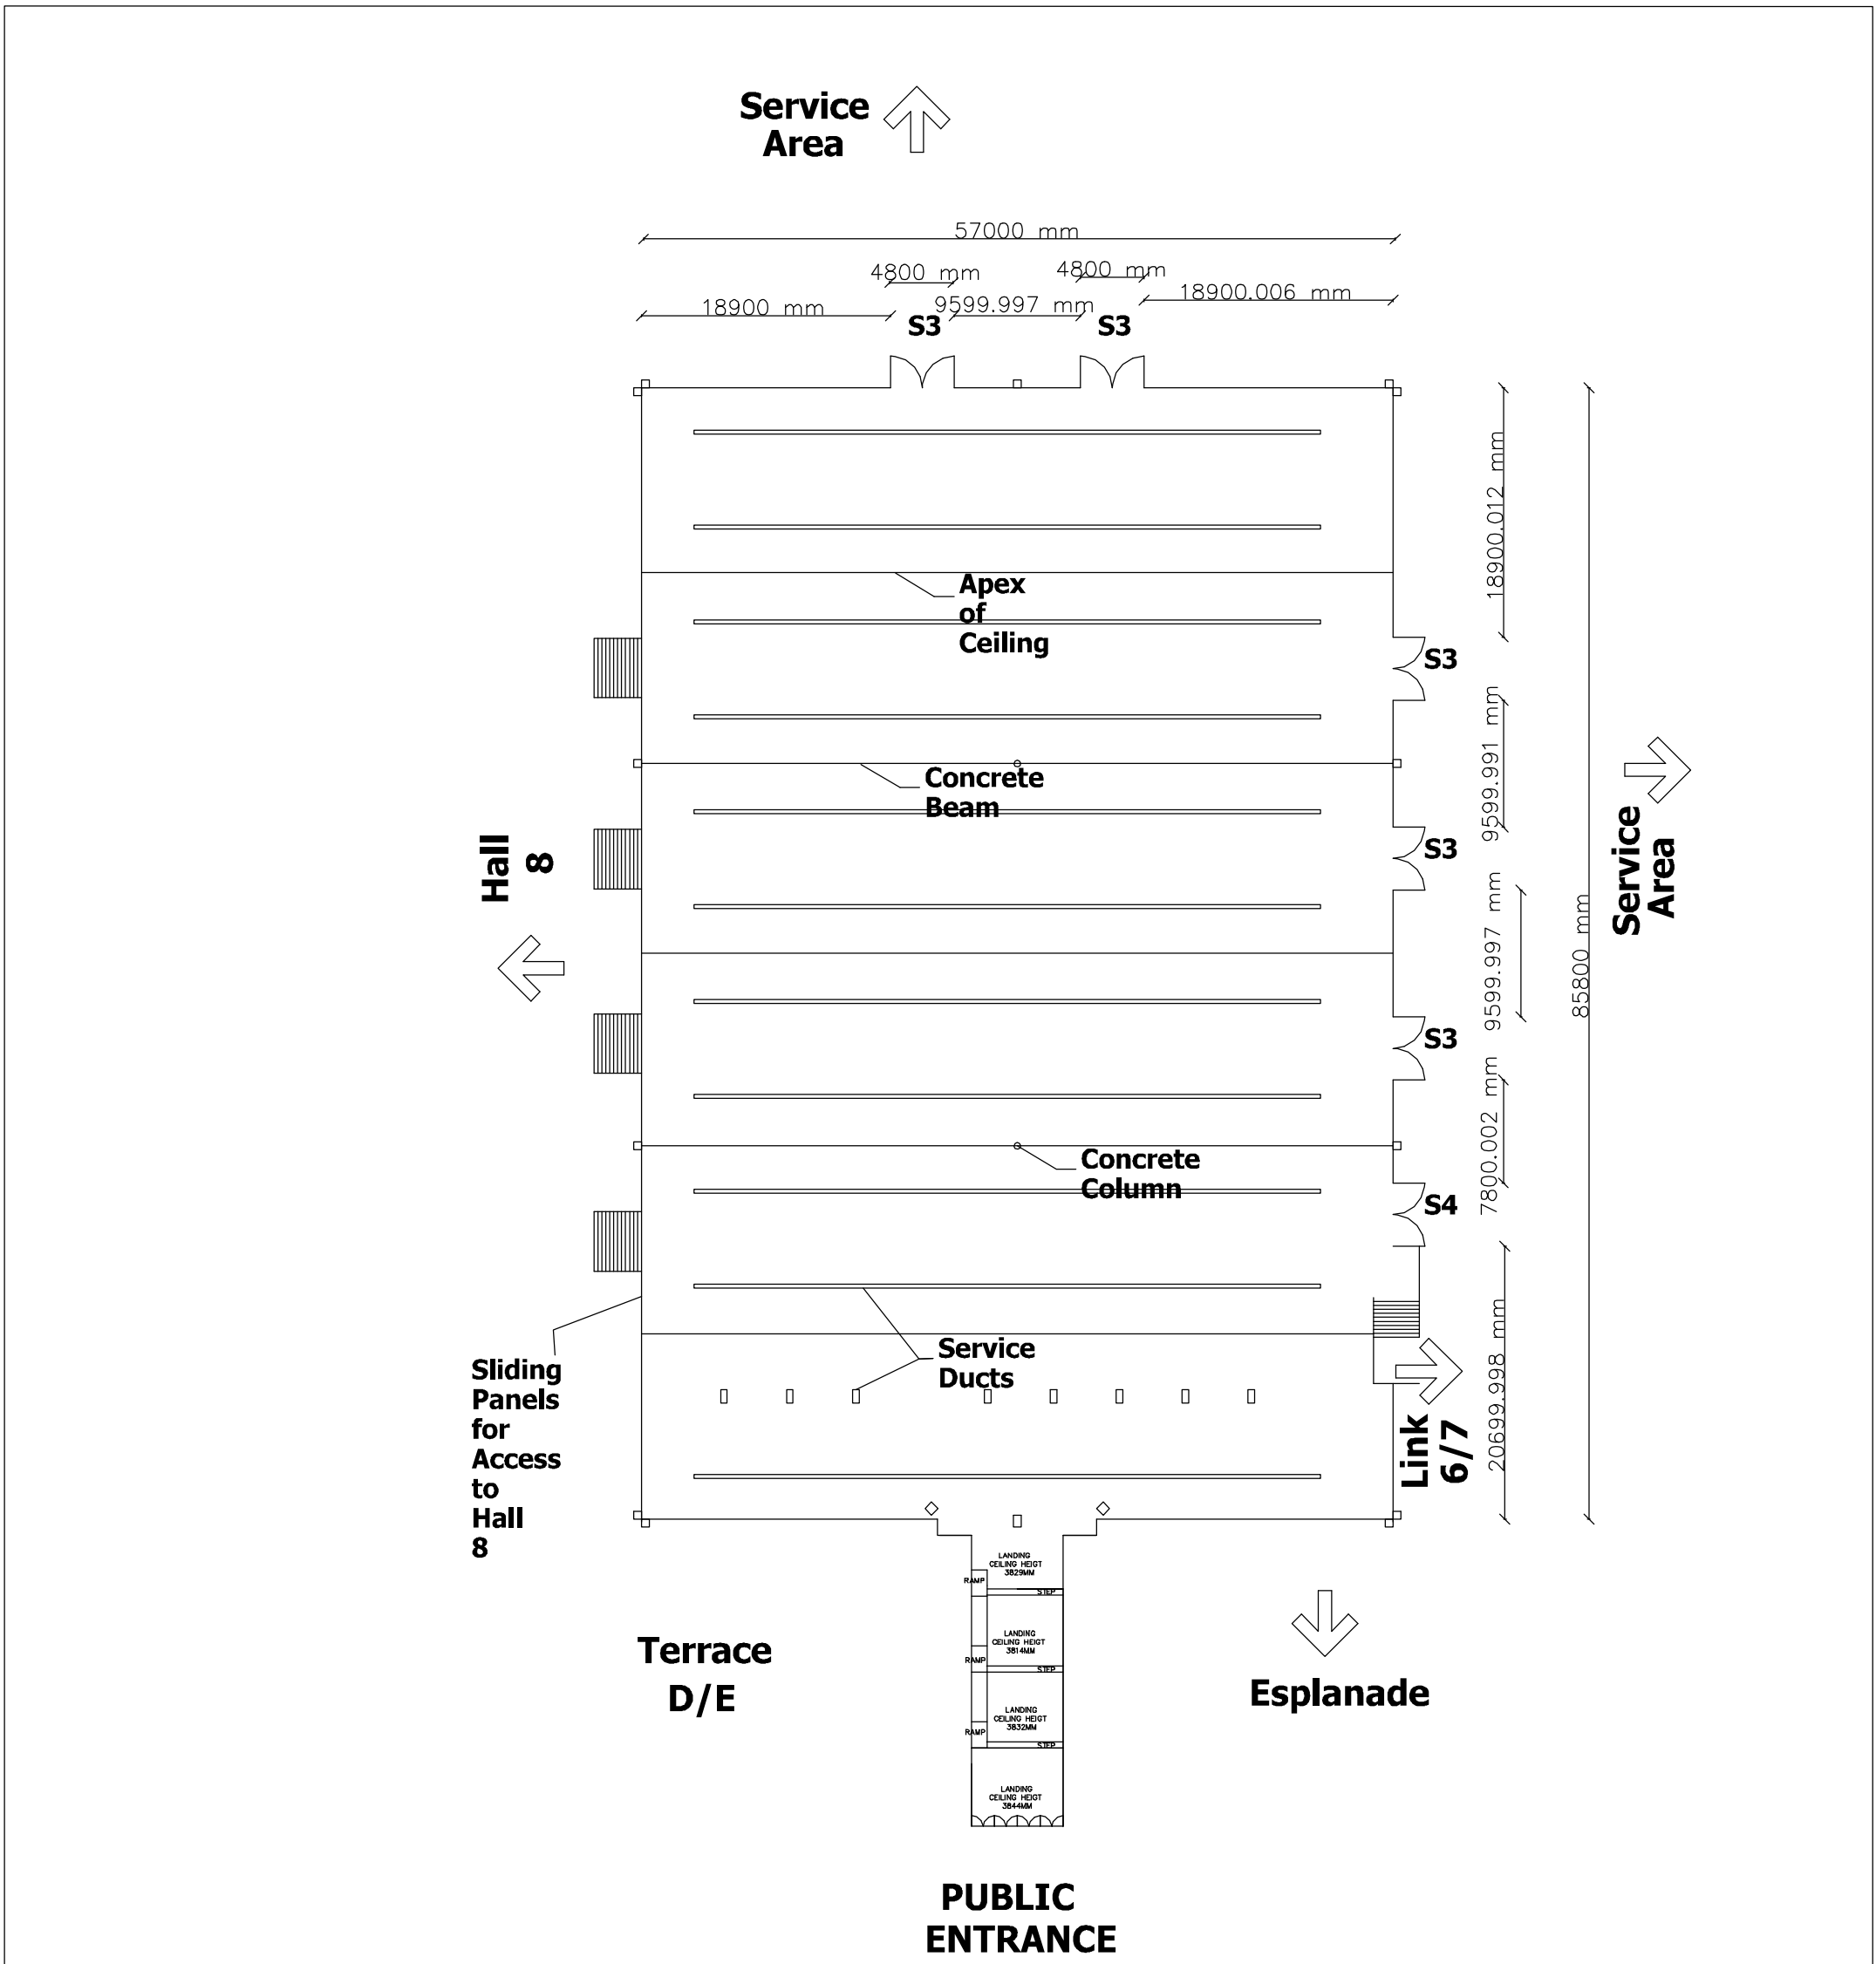

HALL 7

GROSS AREA 4 890M²

NOTE:	SCALE:	LEGEND:	DESCRIPTION:	HEIGHT:	WIDTH:
1. LIGHTING: SODIUM VAPOUR 2. PUBLIC ADDRESS: AVAILABLE ON REQUEST 3. CEILING HEIGHT: AT APEX: 8,2M UNDERSIDE OF CONCRETE BEAMS: 6M 4. CONCRETE COLUMN Ø 600MM 5. SERVICE DUCTS INCLUDE: WATER ELECTRICITY TELEPHONE/FAX 6. FLOOR LOADING: 15 TONNES/M ³ 7. COMPRESSED AIR: AVAILABLE ON REQUEST 8. POWER SUPPLY: 380VOLT 5 WIRE 3 PHASE	1M 10M PLOTTED ON A3: 1:500	⊗ FIRE HOSEREEL AND 2 FIRE EXTINGUISHERS ⊖ FIRE HOSEREEL AND 1 FIRE EXTINGUISHER ○ FIRE HOSEREEL ◇ FIRE EXTINGUISHER	S3 Service Entrance S4 Service Entrance	5,500 m 2,900 m	4,800 m 4,800 m
DISCLAIMER: CARE HAS BEEN TAKEN TO ENSURE THAT MEASUREMENTS ON THIS FLOOR PLAN ARE CORRECT. HOWEVER, IT IS THE CLIENTS RESPONSIBILITY TO VERIFY THE CORRECTNESS OF THE MEASUREMENTS AND INFORMATION.					

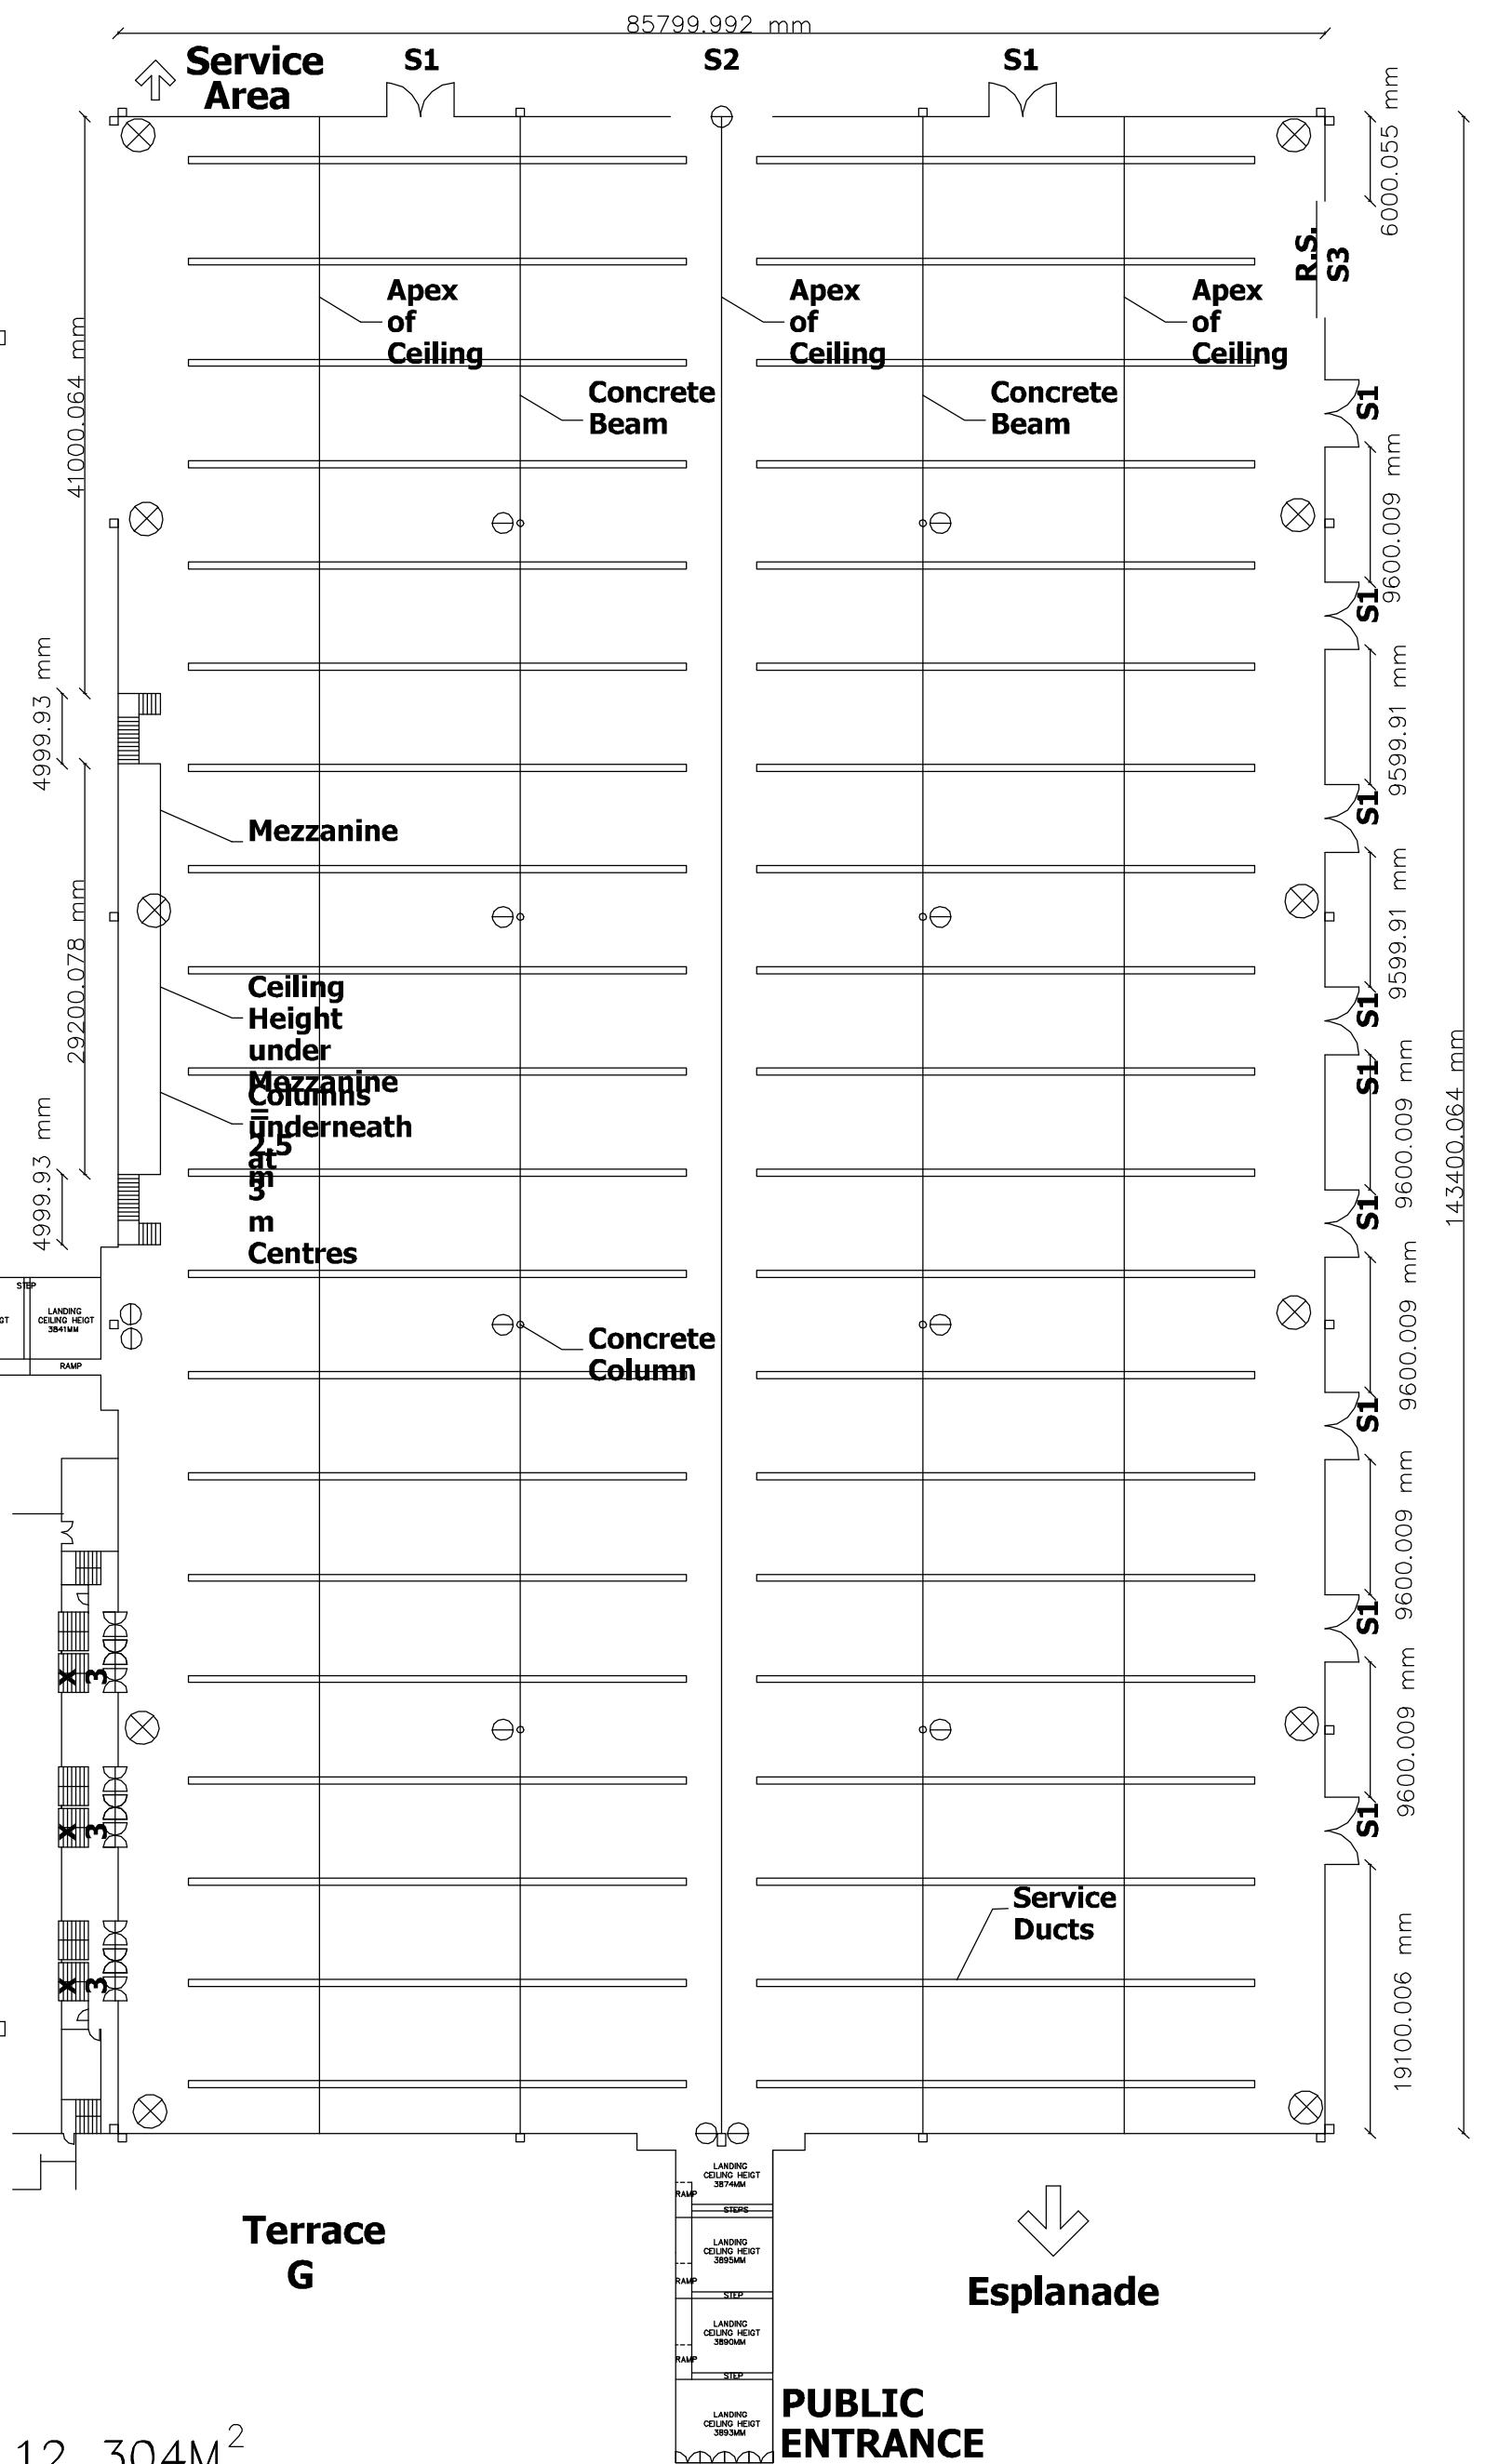

PUBLIC ENTRANCE

Conference Centre

HALL 6
GROSS AREA 12 304M²

NOTE:
 1. LIGHTING: SODIUM VAPOUR
 2. PUBLIC ADDRESS: AVAILABLE ON REQUEST
 3. CEILING HEIGHT:
 AT APEX: 8,2M
 UNDERSIDE OF CONCRETE BEAMS: 6M
 4. CONCRETE COLUMN Ø 600MM
 5. SERVICE DUCTS INCLUDE:
 WATER
 ELECTRICITY
 TELEPHONE/FAX
 6. FLOOR LOADING: 15 TONNES/M³
 7. COMPRESSED AIR: AVAILABLE ON REQUEST
 8. POWER SUPPLY: 380VOLT 5 WIRE 3 PHASE

SCALE:
 1M 10M
PLOTTED ON A3: 1:500


DISCLAIMER:
 CARE HAS BEEN TAKEN TO ENSURE THAT MEASUREMENTS ON THIS FLOOR PLAN ARE CORRECT. HOWEVER, IT IS THE CLIENTS RESPONSIBILITY TO VERIFY THE CORRECTNESS OF THE MEASUREMENTS AND INFORMATION.

LEGEND:

 ○ X FIRE HOSE REEL AND 2 FIRE EXTINGUISHERS
 ○ ● FIRE HOSE REEL AND 1 FIRE EXTINGUISHER
 ○ — FIRE HOSE REEL
 ◇ FIRE EXTINGUISHER


DESCRIPTION:	HEIGHT:	WIDTH:
S1 Service Entrance	4,000 m	4,800 m
S2 Service Entrance	5,600 m	7,200 m
S3 Service Entrance	5,600 m	9,500 m



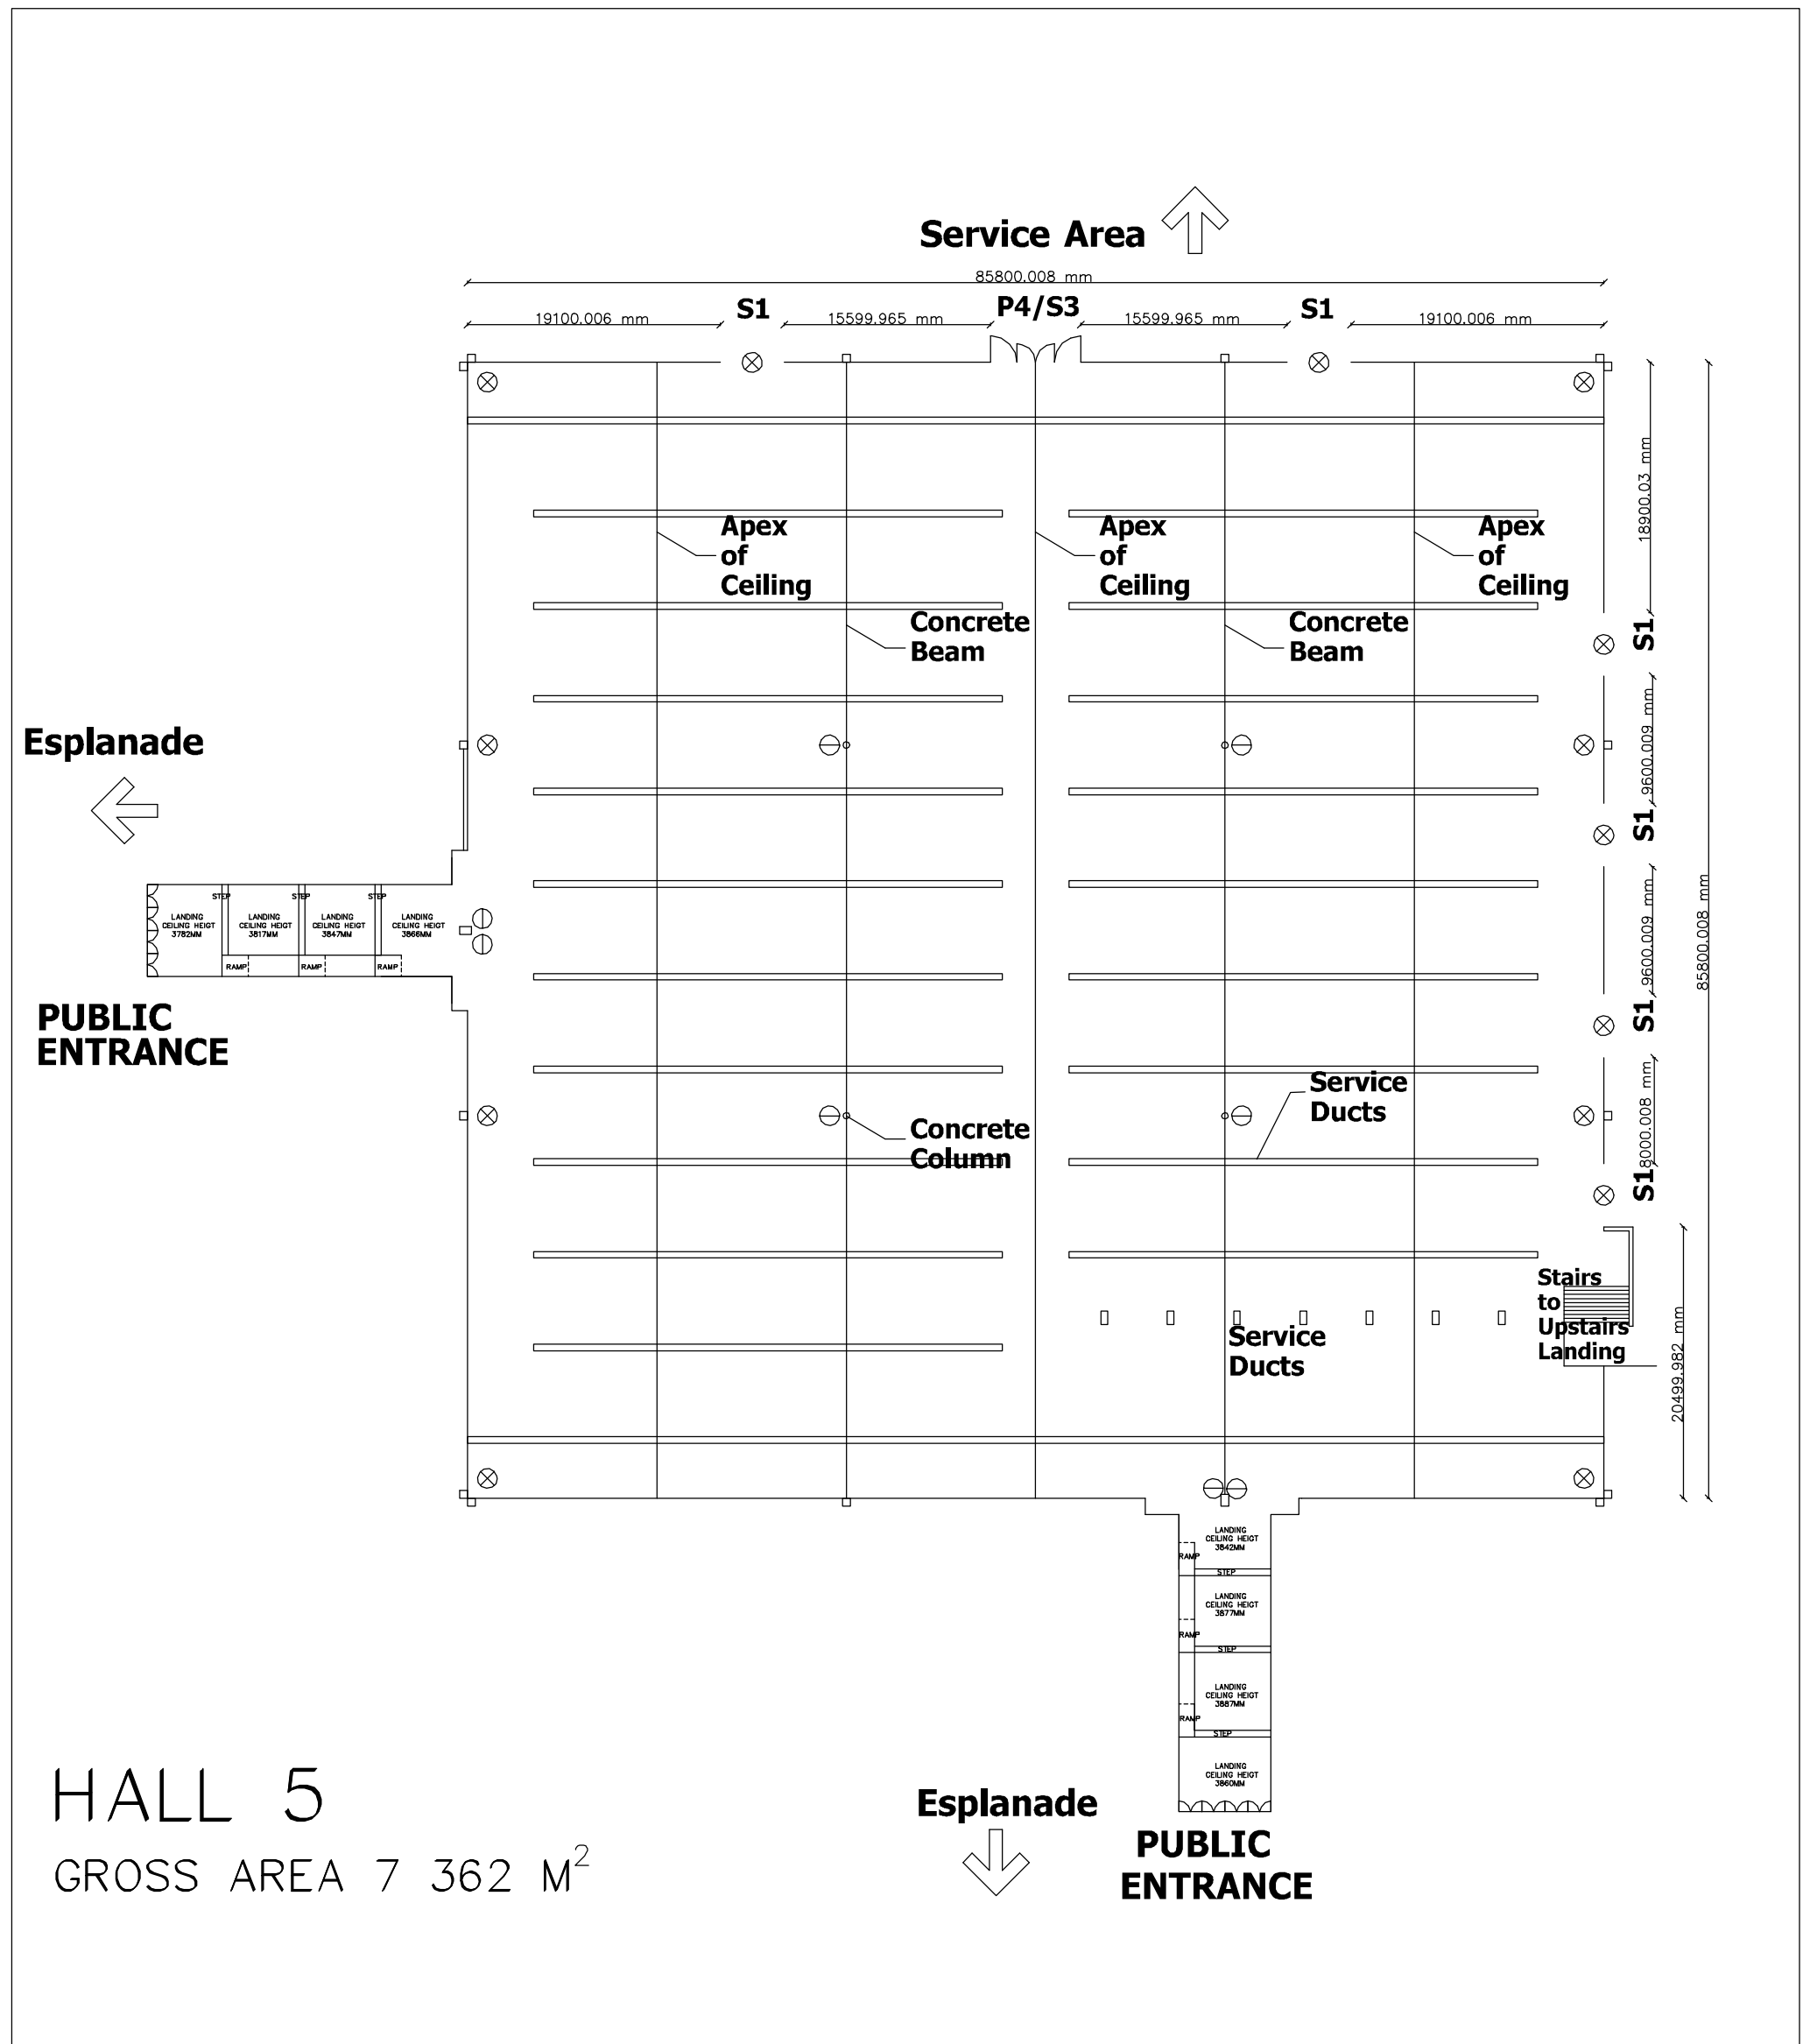


HALL 5
GROSS AREA 7 362 M²

NOTE: 1. LIGHTING: SODIUM VAPOUR 2. PUBLIC ADDRESS: AVAILABLE ON REQUEST 3. CEILING HEIGHT: AT APEX: 8,2M UNDERSIDE OF CONCRETE BEAMS: 6M 4. CONCRETE COLUMN Ø 600MM 5. SERVICE DUCTS INCLUDE: WATER ELECTRICITY TELEPHONE/FAX 6. FLOOR LOADING: 15 TONNES/M ³ 7. COMPRESSED AIR: AVAILABLE ON REQUEST 8. POWER SUPPLY: 380VOLT 5 WIRE 3 PHASE DISCLAIMER: CARE HAS BEEN TAKEN TO ENSURE THAT MEASUREMENTS ON THIS FLOOR PLAN ARE CORRECT. HOWEVER, IT IS THE CLIENTS RESPONSIBILITY TO VERIFY THE CORRECTNESS OF THE MEASUREMENTS AND INFORMATION.	LEGEND: SCALE: PLOTTED ON A3: 1:500	DESCRIPTION: S1 Service Entrance	HEIGHT: 4,000 m	WIDTH: 4,800 m
		S2 Service Entrance	5,600 m	7,200 m

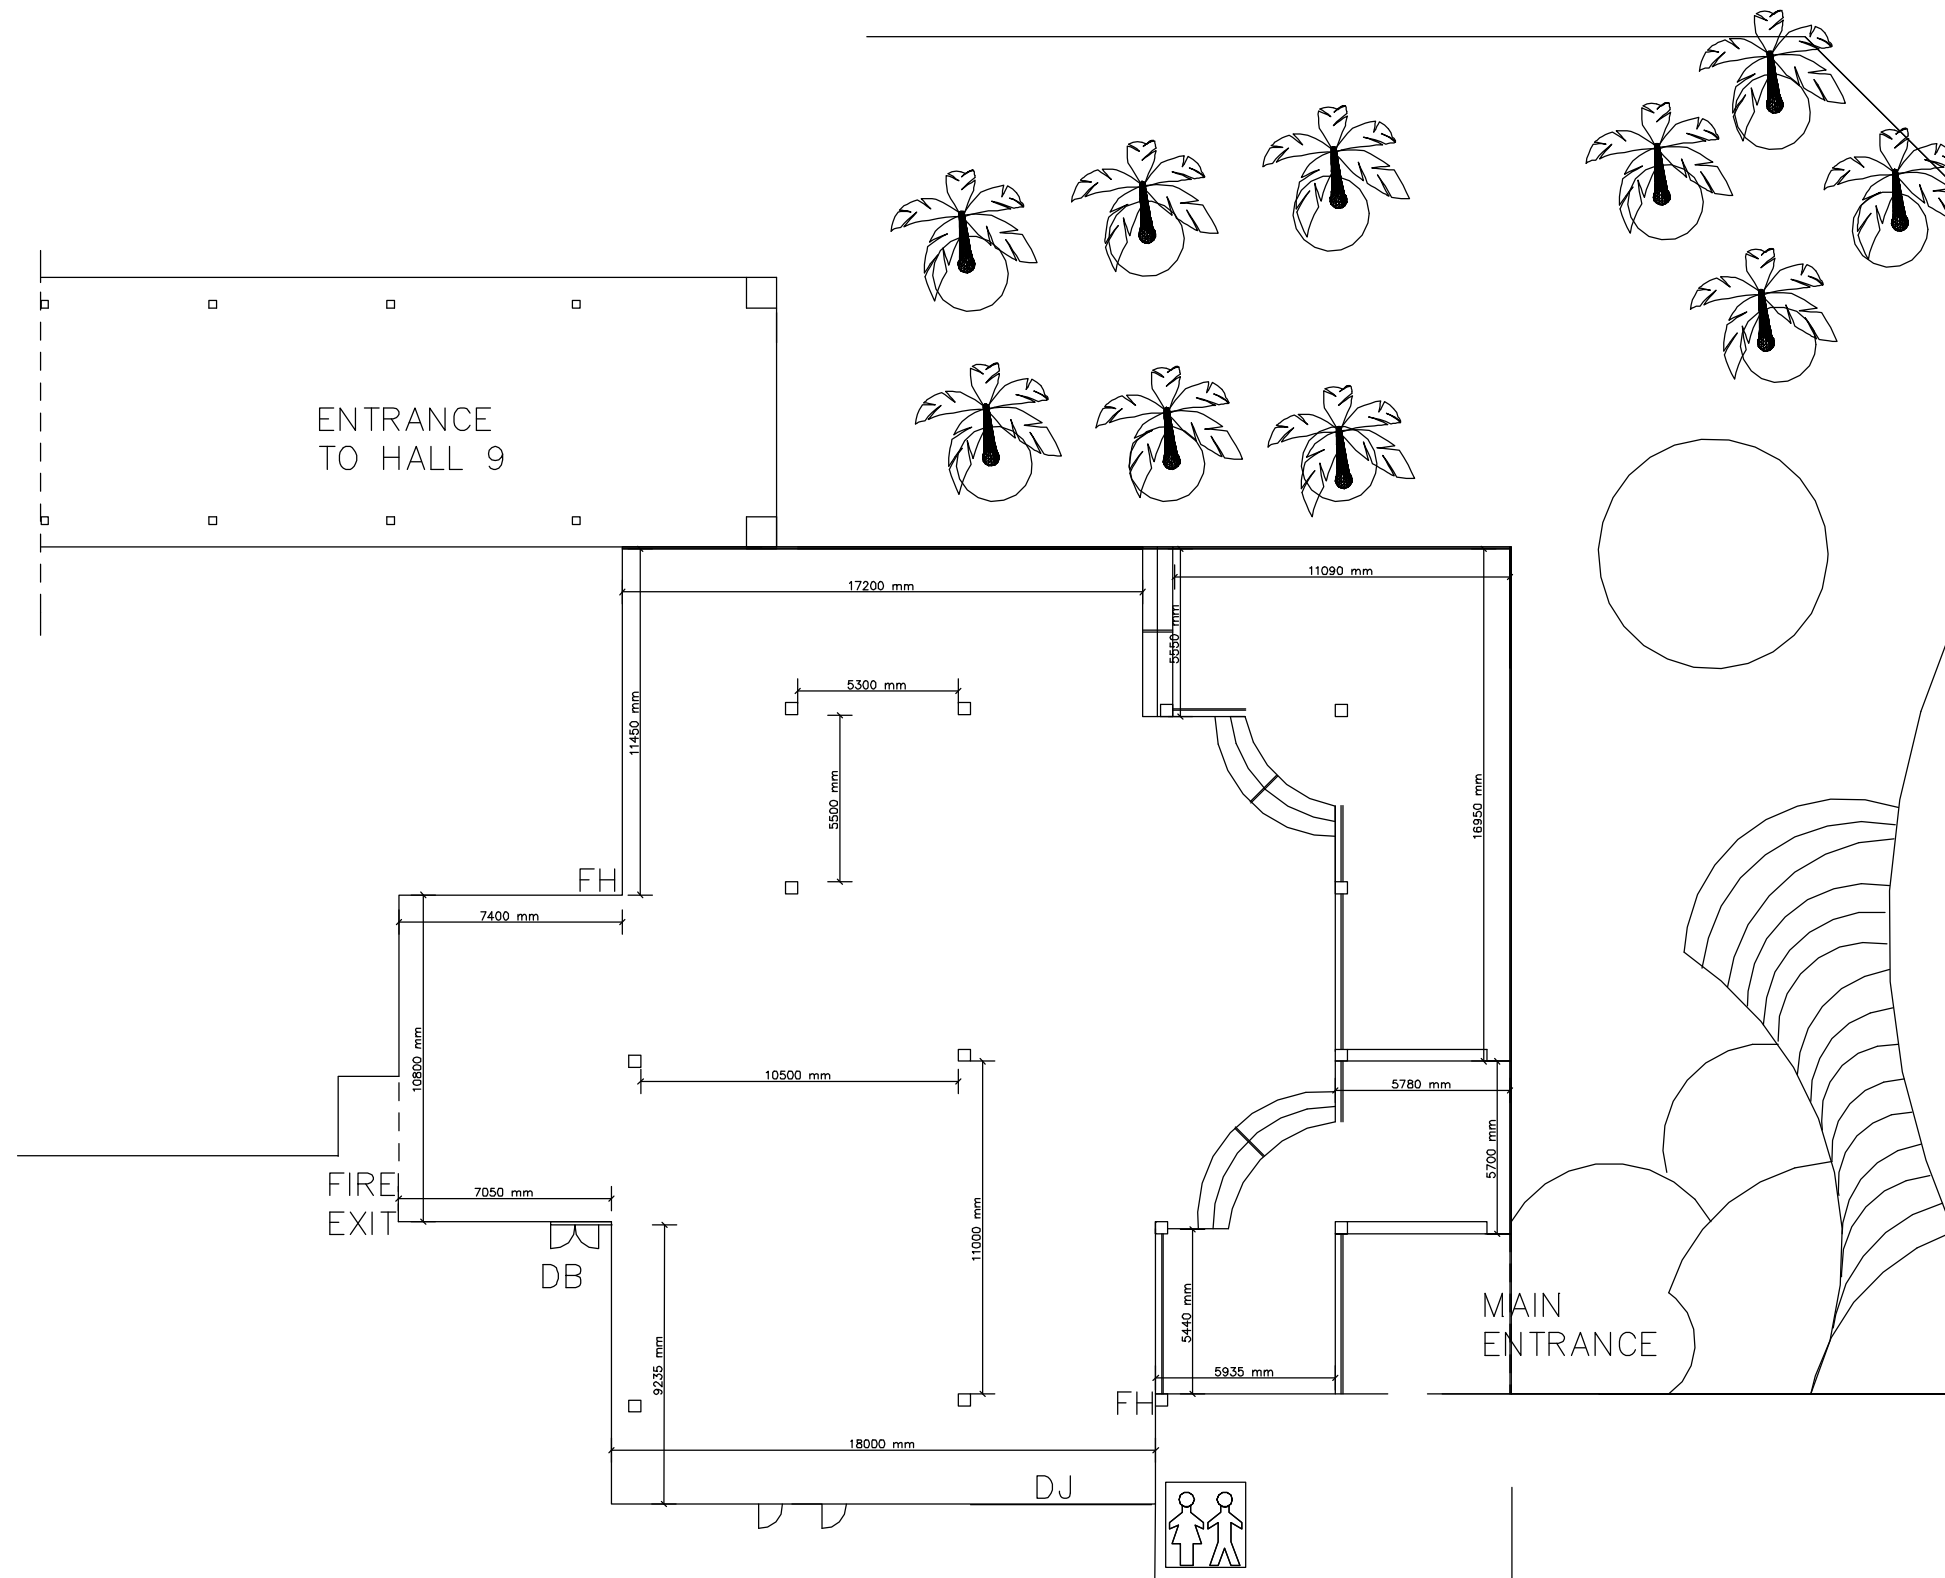


FOODCOURT IN FRONT OF HALL 9

SCALE 1: 250
 DATE: 20/01/2010

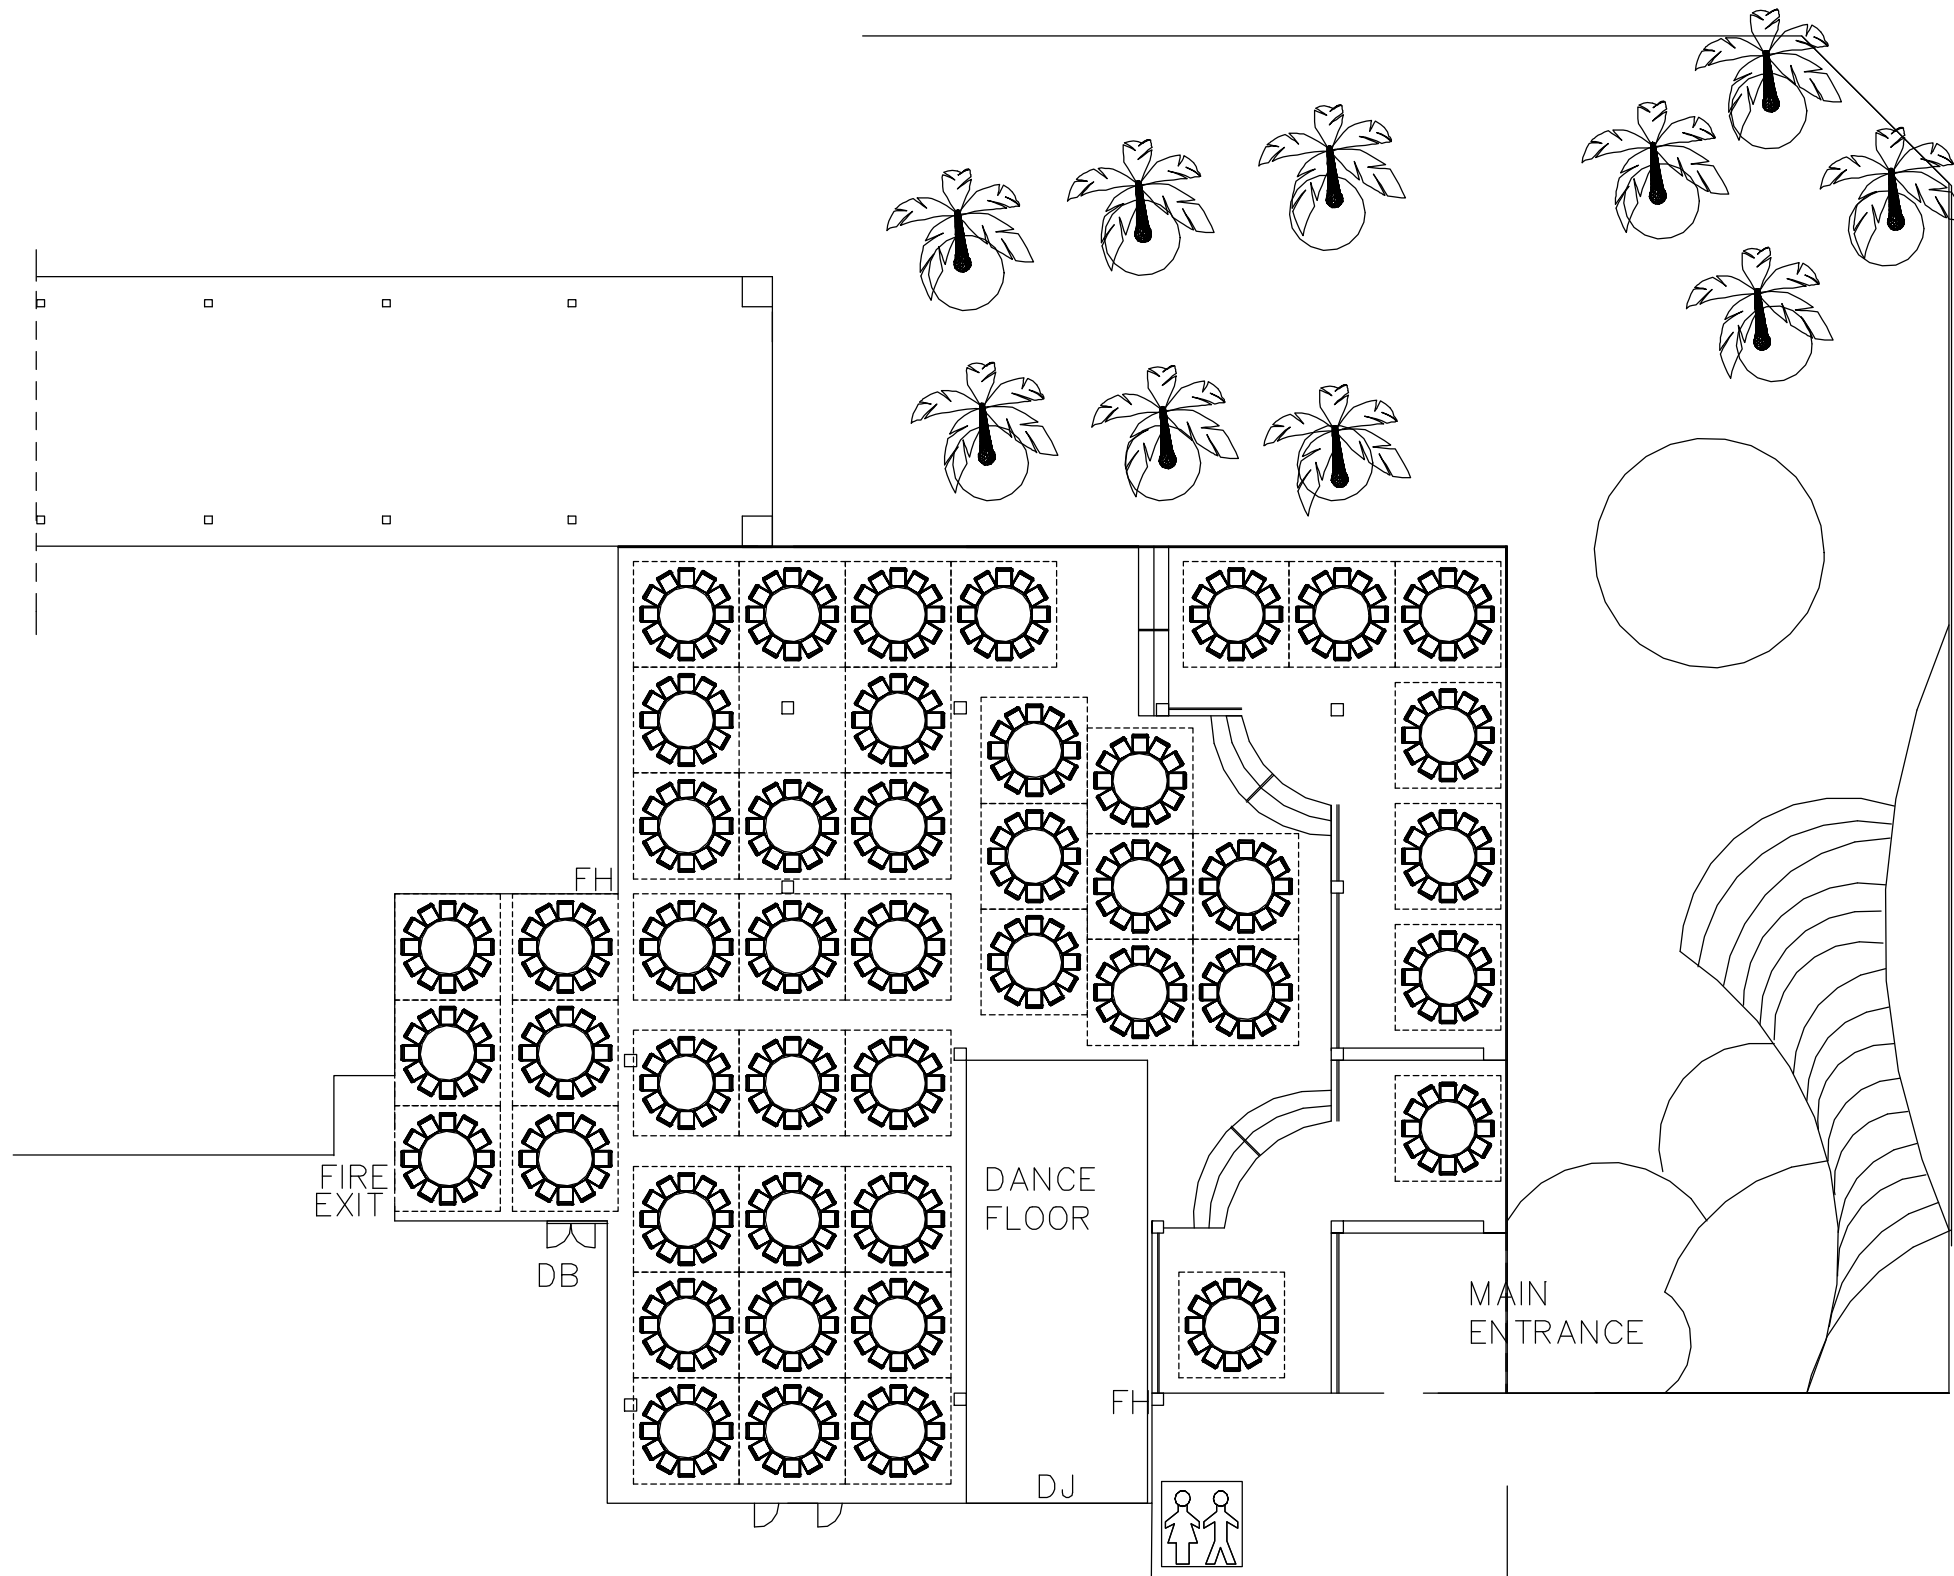


PLACEMENT OF 46 12-SEATER TABLES IN FOODCOURT

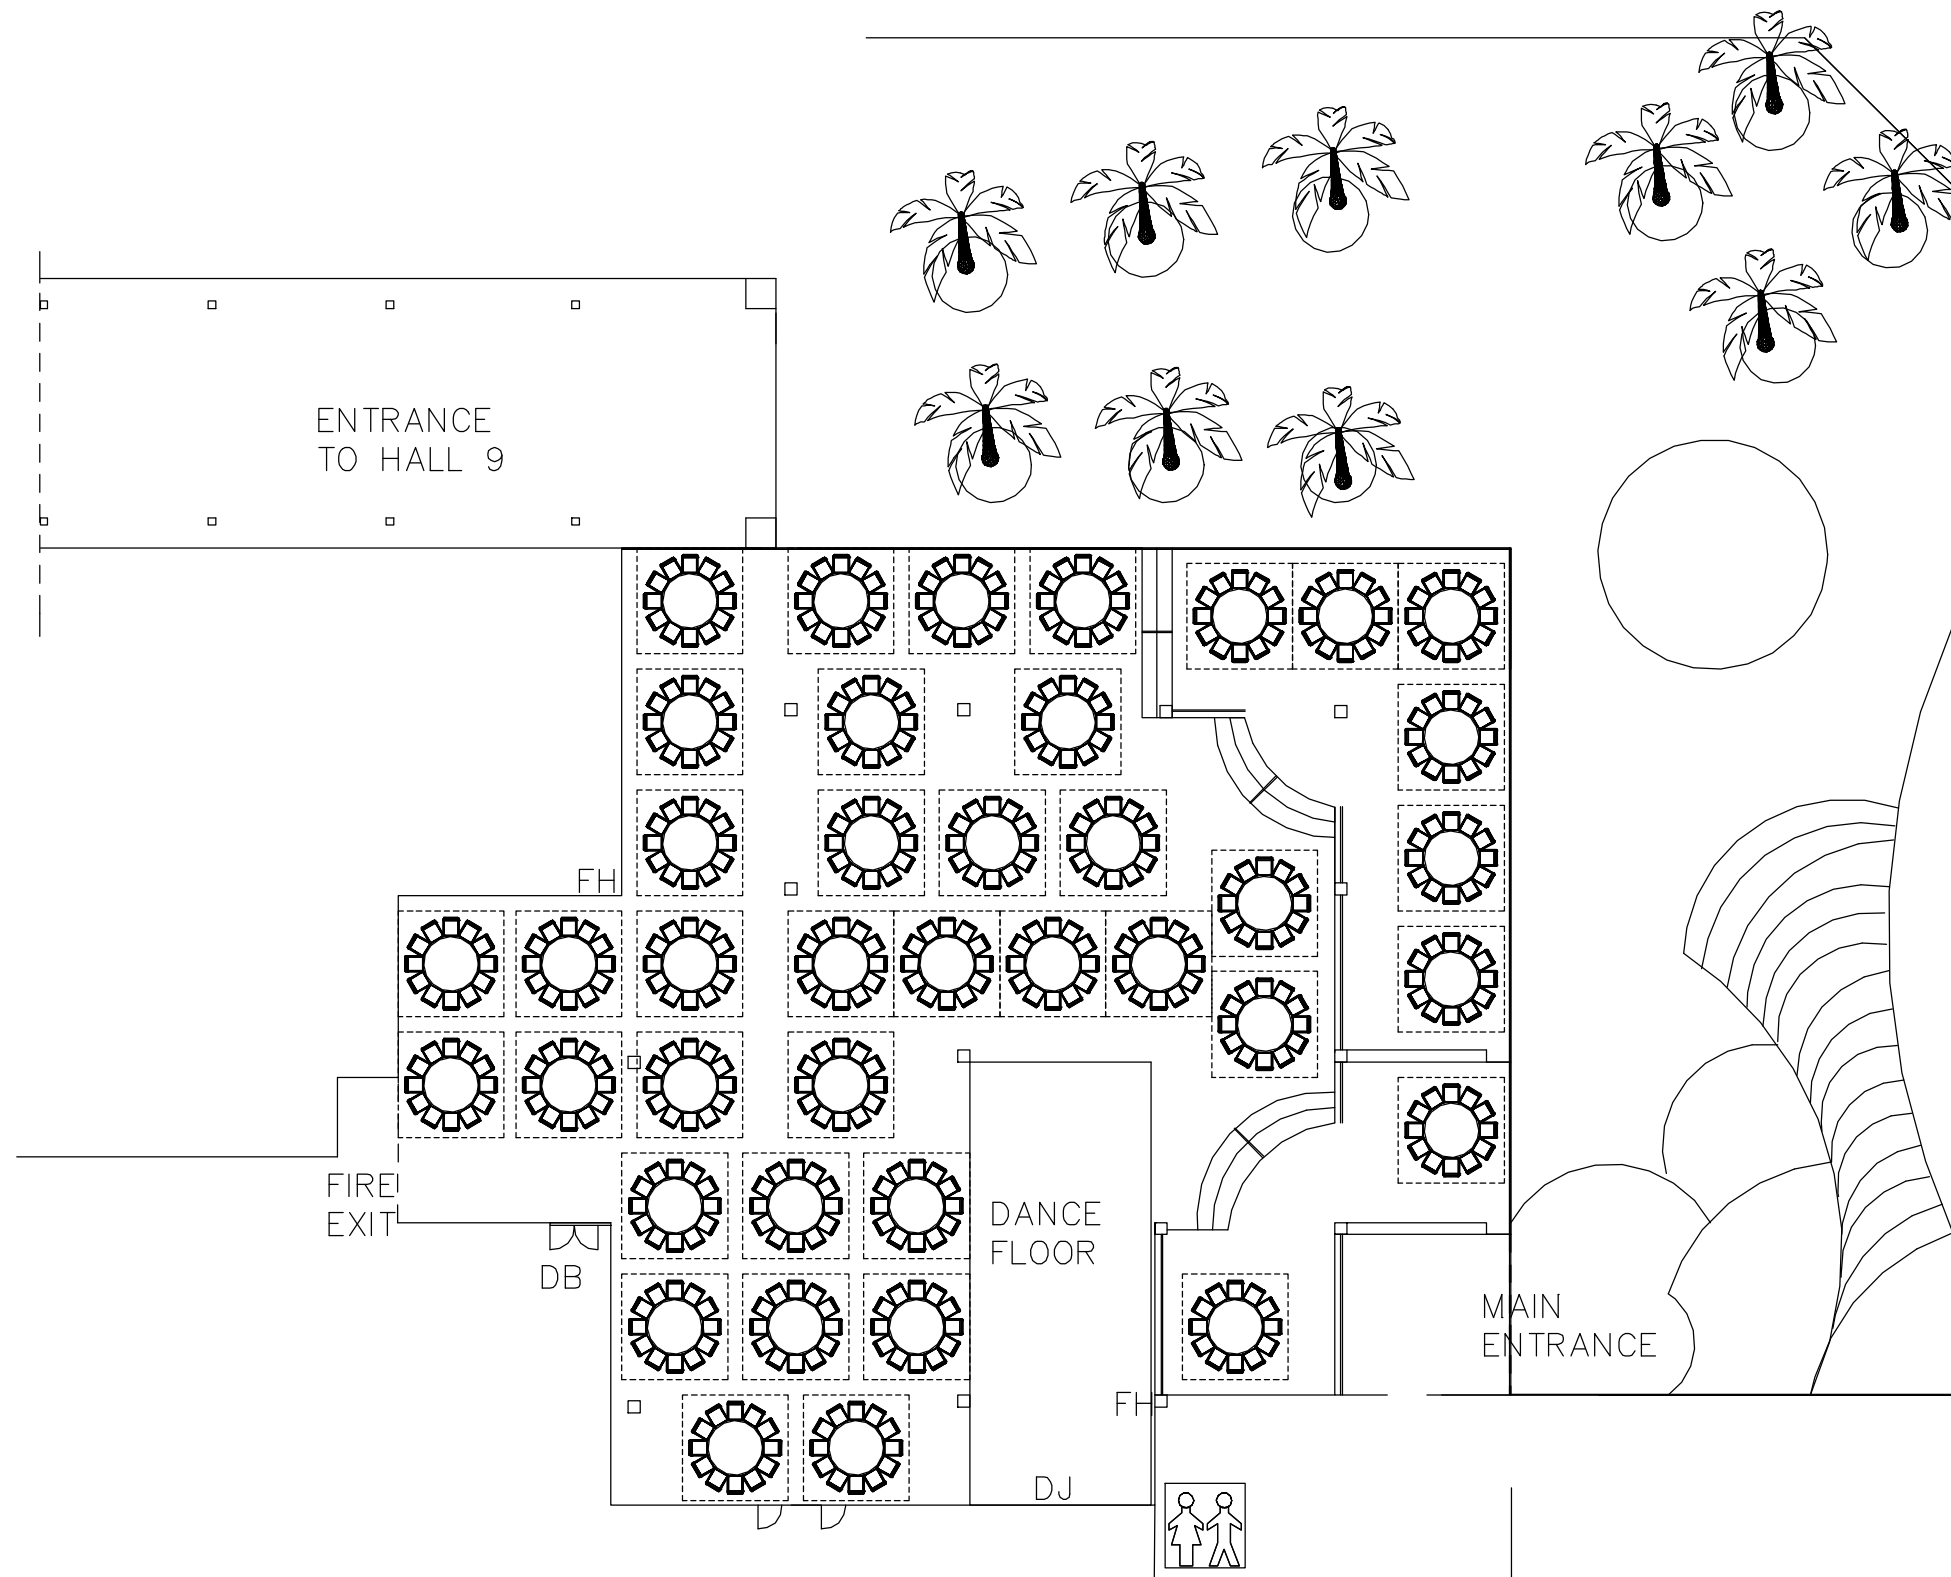


PLACEMENT OF 40 12-SEATER TABLES IN FOODCOURT

 

 


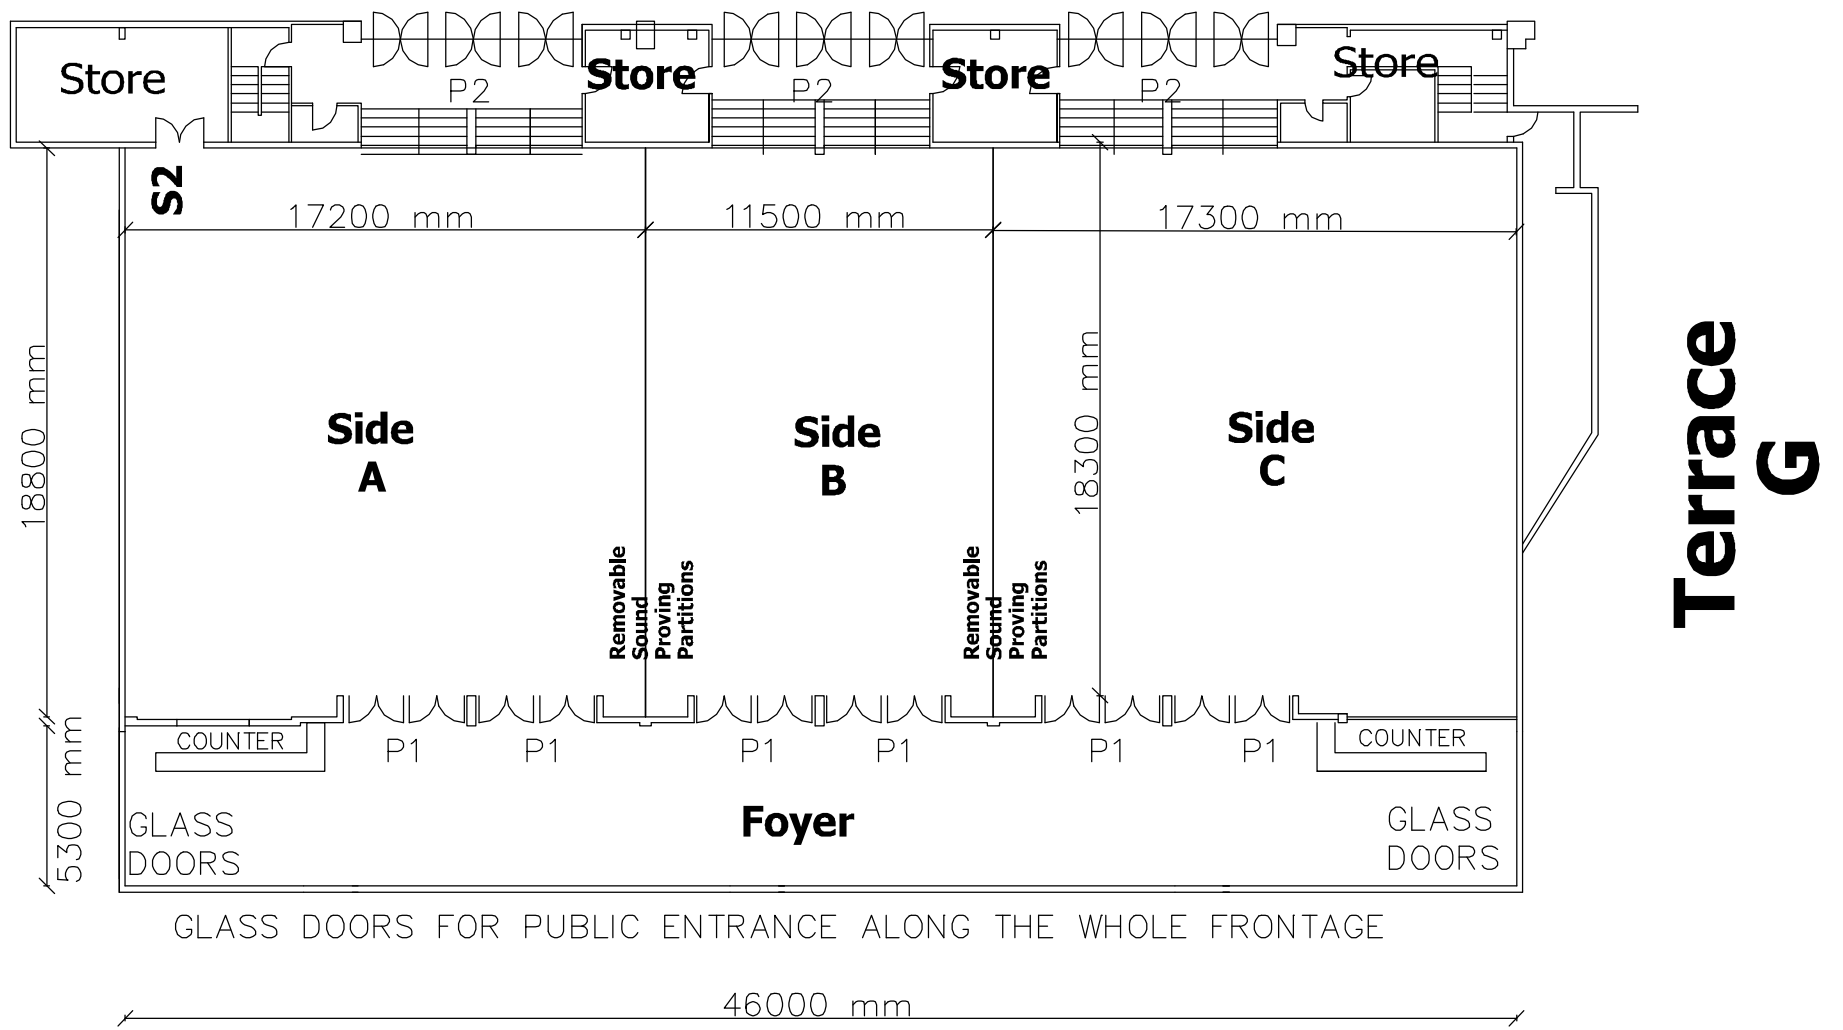

Hall 6

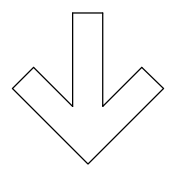
Esplanade




BLACK EAGLE CONFERENCE CENTRE
 GROSS AREA 833M²

<p>NOTE:</p> <ol style="list-style-type: none"> LIGHTING: FLUORESCENT WITH DIMMERS PUBLIC ADDRESS AND CONFERENCE EQUIPMENT: AVAILABLE ON REQUEST CEILING HEIGHT: CONF. CENTRE: 5072 MM FOYER: 3153MM AIRCONDITIONED, CARPETED & SOUND PROOFED <p>SCALE:</p> <p>1M 10M</p>  <p>PLOTTED ON A3: 1:250</p>	<p>LEGEND:</p> <ul style="list-style-type: none">  FIRE HOSEREEL AND 2 FIRE EXTINGUISHERS  FIRE HOSEREEL AND 1 FIRE EXTINGUISHER  FIRE HOSEREEL  FIRE EXTINGUISHER  DISTRIBUTION BOARD <p>DISCLAIMER:</p> <p>CARE HAS BEEN TAKEN TO ENSURE THAT MEASUREMENTS ON THIS FLOOR PLAN ARE CORRECT. HOWEVER, IT IS THE CLIENTS RESPONSIBILITY TO VERIFY THE CORRECTNESS OF THE MEASUREMENTS AND INFORMATION.</p>	<p>DESCRIPTION:</p> <p>P1 PUBLIC ENTRANCE FOYER TO CONFERENCE ROOMS</p> <p>P2 PUBLIC ENTRANCE CONFERENCE ROOMS INTO HALL 6</p> <p>S2 SERVICE DOOR H 1,890M & W 1,480M</p> 
--	---	---


Hall 9

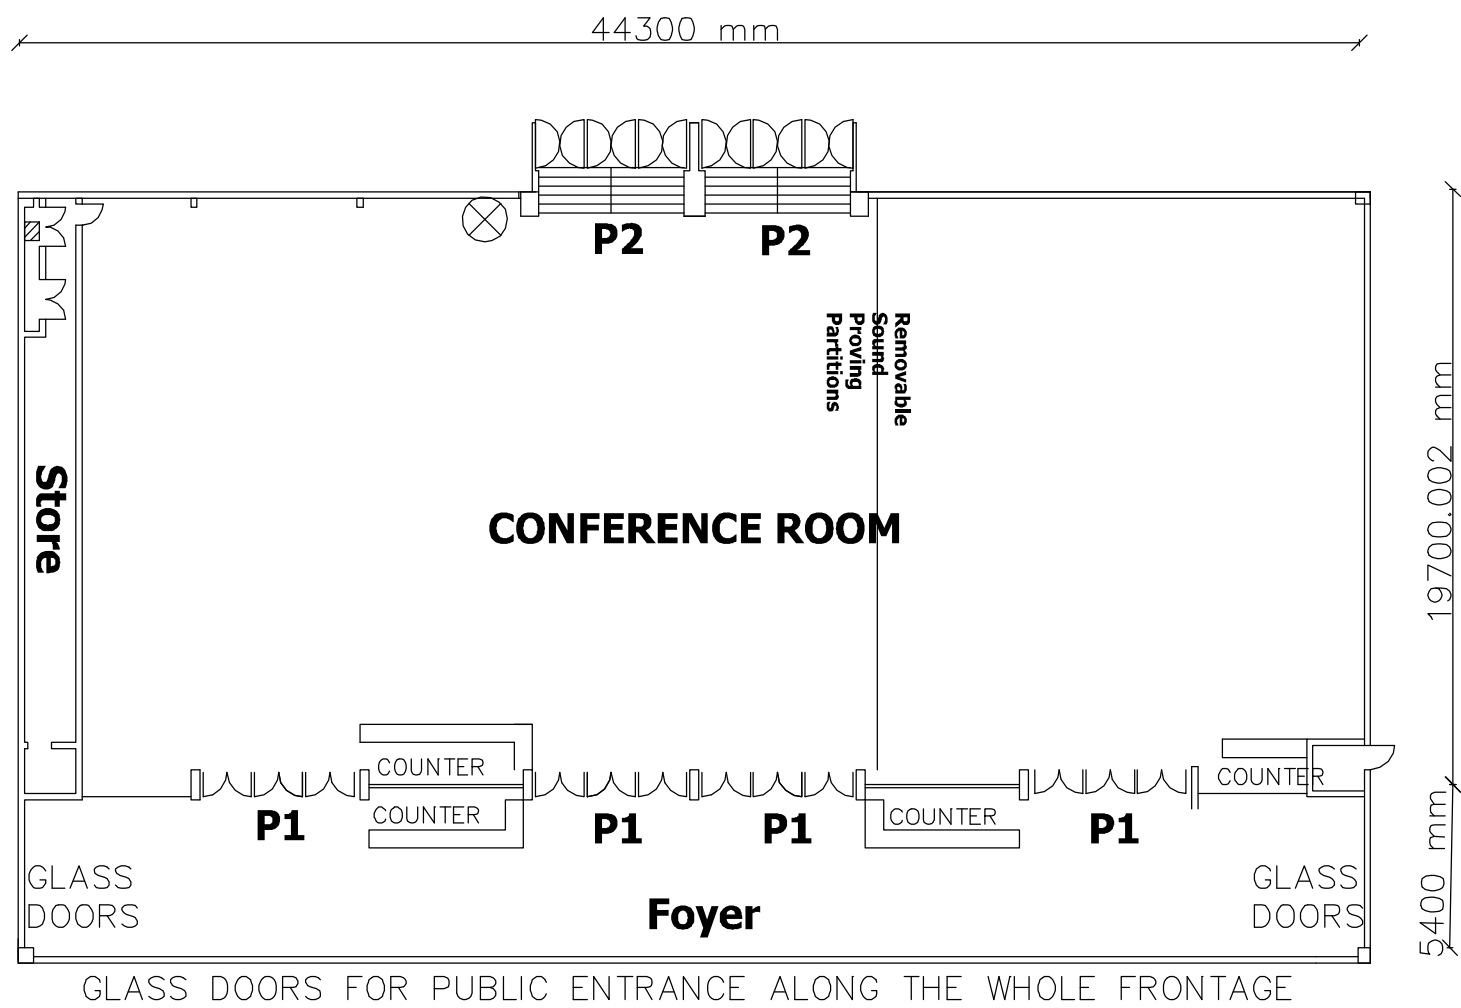

Esplanade

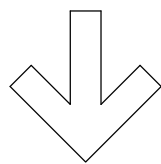

BATELEUR CONFERENCE CENTRE
GROSS AREA 920M²

NOTE:	LEGEND:	DESCRIPTION:
1. LIGHTING: FLUORESCENT WITH DIMMERS 2. PUBLIC ADDRESS AND CONFERENCE EQUIPMENT: AVAILABLE ON REQUEST 3. CEILING HEIGHT: CONF. CENTRE: 4703 MM FOYER: 3012MM 4. AIRCONDITIONED, CARPETED & SOUND PROOFED	<ul style="list-style-type: none"> ⊗ FIRE HOSEREEL AND 2 FIRE EXTINGUISHERS ⊖ FIRE HOSEREEL AND 1 FIRE EXTINGUISHER ○ FIRE HOSEREEL ◇ FIRE EXTINGUISHER ▨ DISTRIBUTION BOARD 	<ul style="list-style-type: none"> P1 PUBLIC ENTRANCE FOYER TO CONFERENCE ROOMS P2 PUBLIC ENTRANCE CONFERENCE ROOMS INTO HALL 9
SCALE: 1M  10M PLOTTED ON A3: 1:250	DISCLAIMER: CARE HAS BEEN TAKEN TO ENSURE THAT MEASUREMENTS ON THIS FLOOR PLAN ARE CORRECT. HOWEVER, IT IS THE CLIENTS RESPONSIBILITY TO VERIFY THE CORRECTNESS OF THE MEASUREMENTS AND INFORMATION.	